



REPUBLIC OF THE PHILIPPINES
TECHNICAL EDUCATION
AND
SKILLS DEVELOPMENT
AUTHORITY

**PLANS FOR THE
INNOVATION CENTER
TESDA SOCCSKSARGEN Manpower
Development Center**

LOCATION: Spring, Alabel City, Saranggani Province

**FOR APPROVAL PLANS OF
REGIONAL TVET INNOVATION
CENTERS (RTICs) 2023**

PROJECT OWNER:



TECHNICAL EDUCATION
AND
SKILLS DEVELOPMENT
AUTHORITY

MAIN OFFICE ADDRESS: TESDA COMPLEX, East Service Road SLEX, Taguig City

PROJECT TITLE:

PROPOSED TESDA SOCCSKSARGEN
INNOVATION CENTER

LOCATION: Spring, Alabel City, Saranggani Province

ARCHITECT:


AR. RANIEL A. MENDOZA
HEAD, PMU-SIPTVETS
ENGINEERING SECTION

PROJECT MANAGER:


DIR. ENRICO C. BANARIO
PMU-SIPTVETS

PROJECT DIRECTOR:


SEC. SUHARTO T. MANGUDADATU, Ph.D.
PMU-SIPTVETS
SECRETARY, TESDA

SHEET CONTENTS:

PROJECT TITLE PAGE

SHEET NO.

CS-1



TESDA INNOVATION CENTER - SOCCSKSARGEN
EXTERIOR PERSPECTIVE 01



SCALE:

NTS



TESDA INNOVATION CENTER - SOCCSKSARGEN
SITE DEVELOPMENT PLAN



SCALE:

NTS



TESDA INNOVATION CENTER - SOCCSKSARGEN
VICINITY/LOCATION MAP



SCALE:

NTS

**FOR APPROVAL PLANS OF
REGIONAL TVET INNOVATION
CENTERS (RTICs) 2023**



**TECHNICAL EDUCATION
AND
SKILLS DEVELOPMENT
AUTHORITY**

MAIN OFFICE ADDRESS: TESDA COMPLEX, East Service Road SLEX, Taguig City

PROJECT TITLE:

**PROPOSED TESDA SOCCSKSARGEN
INNOVATION CENTER**

LOCATION: Spring, Abul City, Sarangani Province

ARCHITECT:

[Signature]
AR. RUMEL A. MENDOZA
HEAD, PMU-SIPTVETS
ENGINEERING SECTION

PROJECT MANAGER:

[Signature]
DIR. ENRICO C. BANARIO
PMU-SIPTVETS

PROJECT DIRECTOR:

[Signature]
SEC. SUHARTO T. MANGUDADATU, Ph.D.
PMU-SIPTVETS
SECRETARY, TESDA

SHEET CONTENTS:
EXTERIOR PERSPECTIVE
SITE DEVELOPMENT PLAN
VICINITY MAP

SHEET NO.

CS-2



TESDA INNOVATION CENTER - SOCCSKSARGEN
SITE DEVELOPMENT PLAN

1:750 MTS

SCALE:

FOR APPROVAL PLANS OF
REGIONAL TVET INNOVATION
CENTERS (RTICs) 2023

PROJECT OWNER:



TECHNICAL EDUCATION
AND
SKILLS DEVELOPMENT
AUTHORITY

MAIN OFFICE ADDRESS: TESDA COMPLEX, East Service Road SLEX, Taguig City

PROJECT TITLE:

PROPOSED TESDA SOCCSKSARGEN
INNOVATION CENTER

LOCATION: Spring, Alabel City, Sarangani Province

ARCHITECT:

AR. RONIEL A. MENDOZA
HEAD, PMU-SIPTVETS
ENGINEERING SECTION

PROJECT MANAGER:

DIR. ENRICO C. BANARIO
PMU-SIPTVETS


PROJECT DIRECTOR:

SEC. SUHARTO T. MANGUDADATU, Ph.D.
PMU-SIPTVETS
SECRETARY, TESDA

SHEET CONTENTS:
SITE DEVELOPMENT PLAN

SHEET NO.

A-0

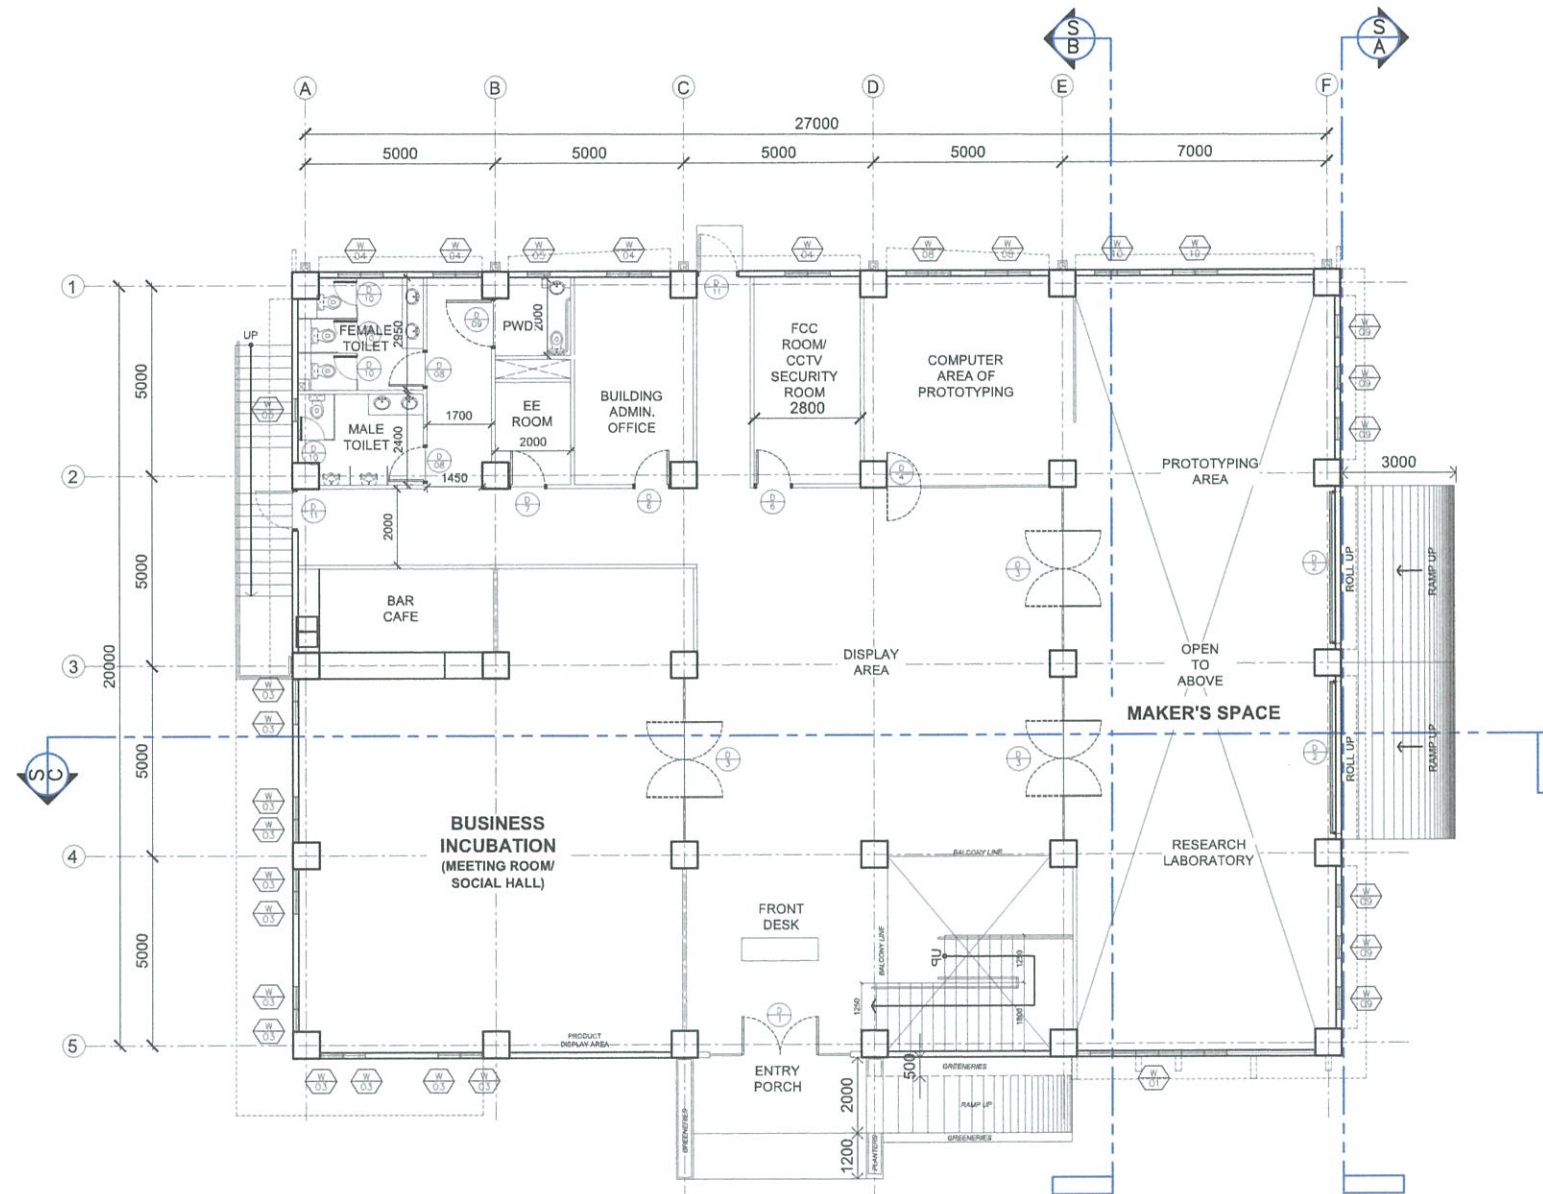

A
TESDA INNOVATION CENTER - SOCCSKSARGEN
GROUND FLOOR PLAN
 SCALE 1:200 MTS

**FOR APPROVAL PLANS OF
REGIONAL TVET INNOVATION
CENTERS (RTICs) 2023**

PROJECT OWNER:



**TECHNICAL EDUCATION
AND
SKILLS DEVELOPMENT
AUTHORITY**

MAIN OFFICE ADDRESS: TESDA COMPLEX, East Service Road SLEX, Taguig City;

PROJECT TITLE:

**PROPOSED TESDA SOCCSKSARGEN
INNOVATION CENTER**

LOCATION: Spring, Alabul City, Saranggani Province

ARCHITECT:

[Signature]
AR. RUMEL A. MENDOZA
 HEAD, PMU-SIPTVETS
 ENGINEERING SECTION

PROJECT MANAGER:

[Signature]
DIR. ENRICO C. BANARIO
 PMU-SIPTVETS


PROJECT DIRECTOR:

[Signature]
SEC. SUHARTO T. MANGUDADATU, Ph.D.
 PMU-SIPTVETS
 SECRETARY, TESDA

SHEET CONTENTS:
GROUND FLOOR PLAN

SHEET NO.

A-1

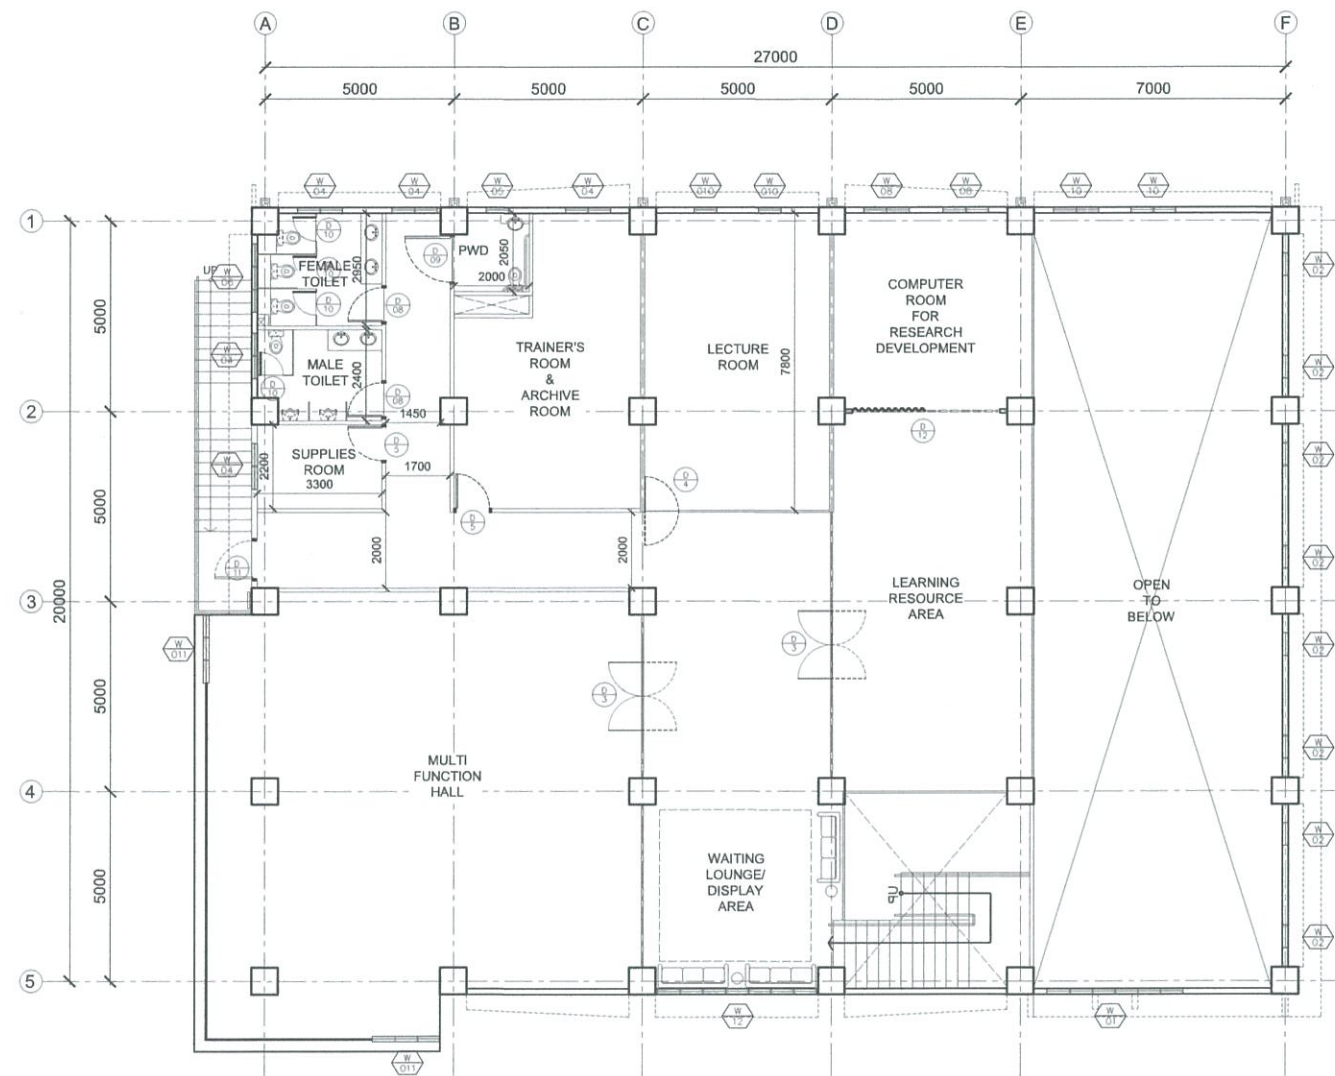

A
TESDA INNOVATION CENTER - SOCCSKSARGEN
SECOND FLOOR PLAN
 SCALE 1:200 MTS

**FOR APPROVAL PLANS OF
REGIONAL TVET INNOVATION
CENTERS (RTICs) 2023**

PROJECT OWNER:



**TECHNICAL EDUCATION
AND
SKILLS DEVELOPMENT
AUTHORITY**

MAIN OFFICE ADDRESS: TESDA COMPLEX, East Service Road BLEX, Taguig City;

PROJECT TITLE:

**PROPOSED TESDA SOCCSKSARGEN
INNOVATION CENTER**

LOCATION: Spring, Abul City, Sarangani Province

ARCHITECT:

[Signature]
MR. RUMIEL A. MENDOZA
 HEAD, PMU-SIPTVETS
 ENGINEERING SECTION

PROJECT MANAGER:

[Signature]
DIR. ENRICO C. BANARIO
 PMU-SIPTVETS


PROJECT DIRECTOR:

[Signature]
SEC. SUHARTO T. MANGUDADATU, Ph.D.
 PMU-SIPTVETS
 SECRETARY, TESDA

SHEET CONTENTS:
SECOND FLOOR PLAN

SHEET NO.

A-2

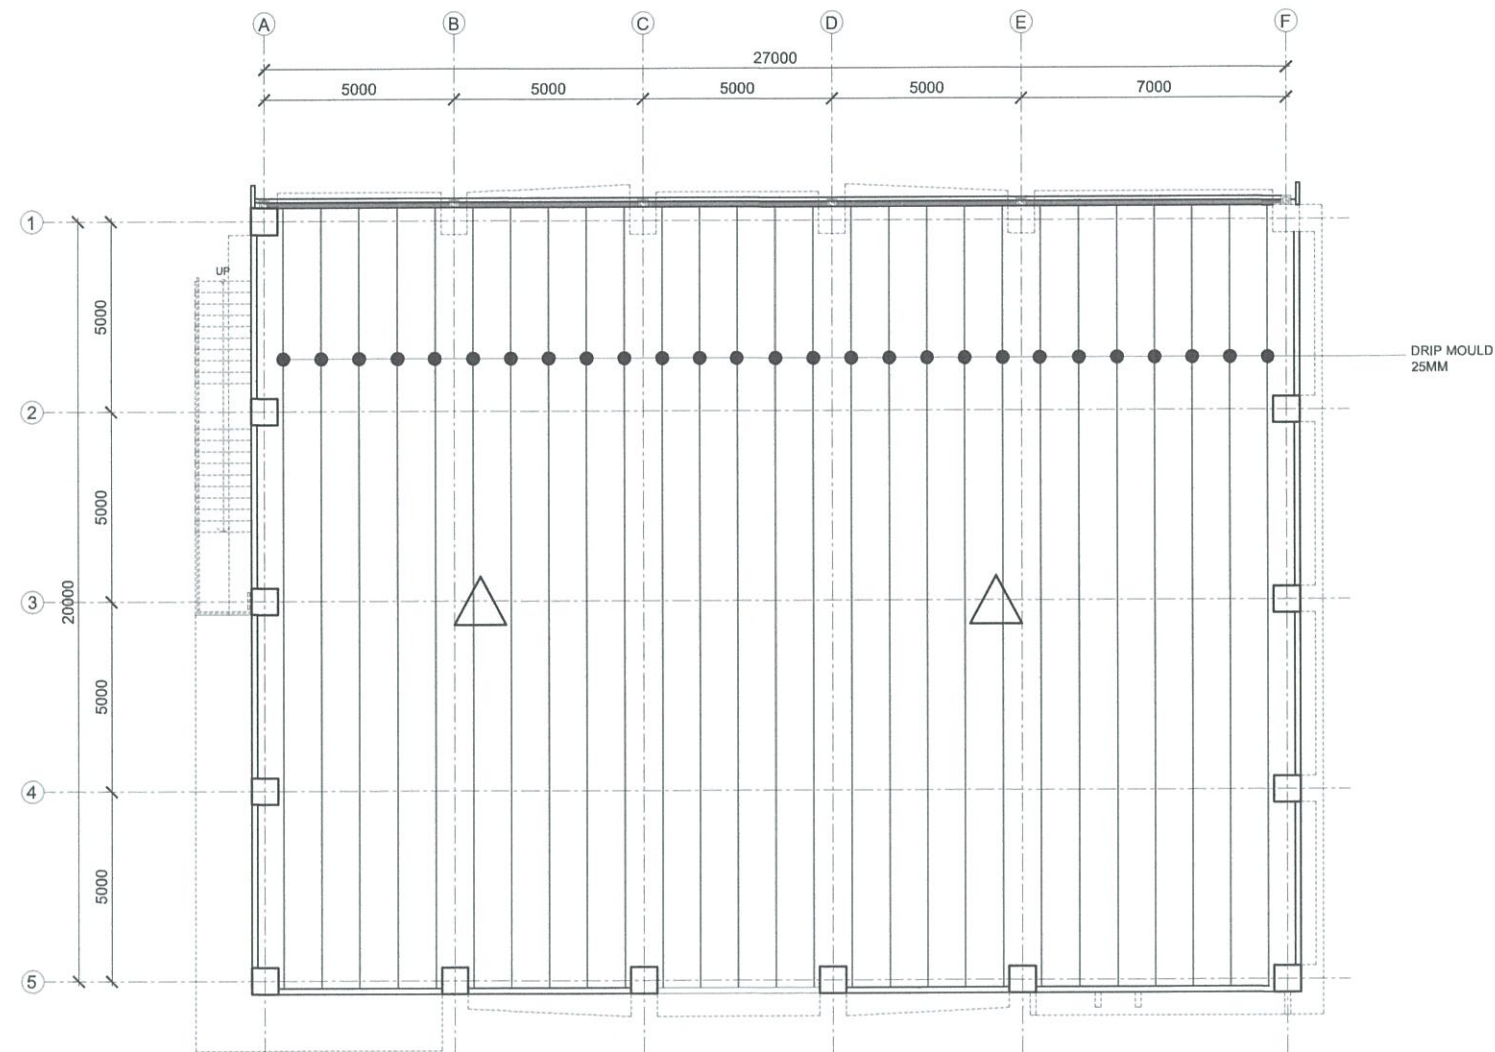

A
 TESDA INNOVATION CENTER - SOCCSKSARGEN
ROOF SLAB FLOOR PLAN
 SCALE 1:200 MTS

**FOR APPROVAL PLANS OF
REGIONAL TVET INNOVATION
CENTERS (RTICs) 2023**



**TECHNICAL EDUCATION
AND
SKILLS DEVELOPMENT
AUTHORITY**

MAIN OFFICE ADDRESS: TESDA COMPLEX, East Service Road SLEX, Taguig City

PROJECT TITLE:

**PROPOSED TESDA SOCCSKSARGEN
INNOVATION CENTER**

LOCATION: Spring, Alabul City, Sarangani Province

ARCHITECT:

[Signature]
AR. DANIEL A. MENDOZA
 HEAD, PMU-SIPTVETS
 ENGINEERING SECTION

PROJECT MANAGER:

[Signature]
DIR. ENRICO C. BANARIO
 PMU-SIPTVETS


PROJECT DIRECTOR:

[Signature]
SEC. SUHARTO T. MANGUDADATU, Ph.D.
 PMU-SIPTVETS
 SECRETARY, TESDA


SHEET CONTENTS:
 ROOF SLAB DECK PLAN

SHEET NO.

A-3

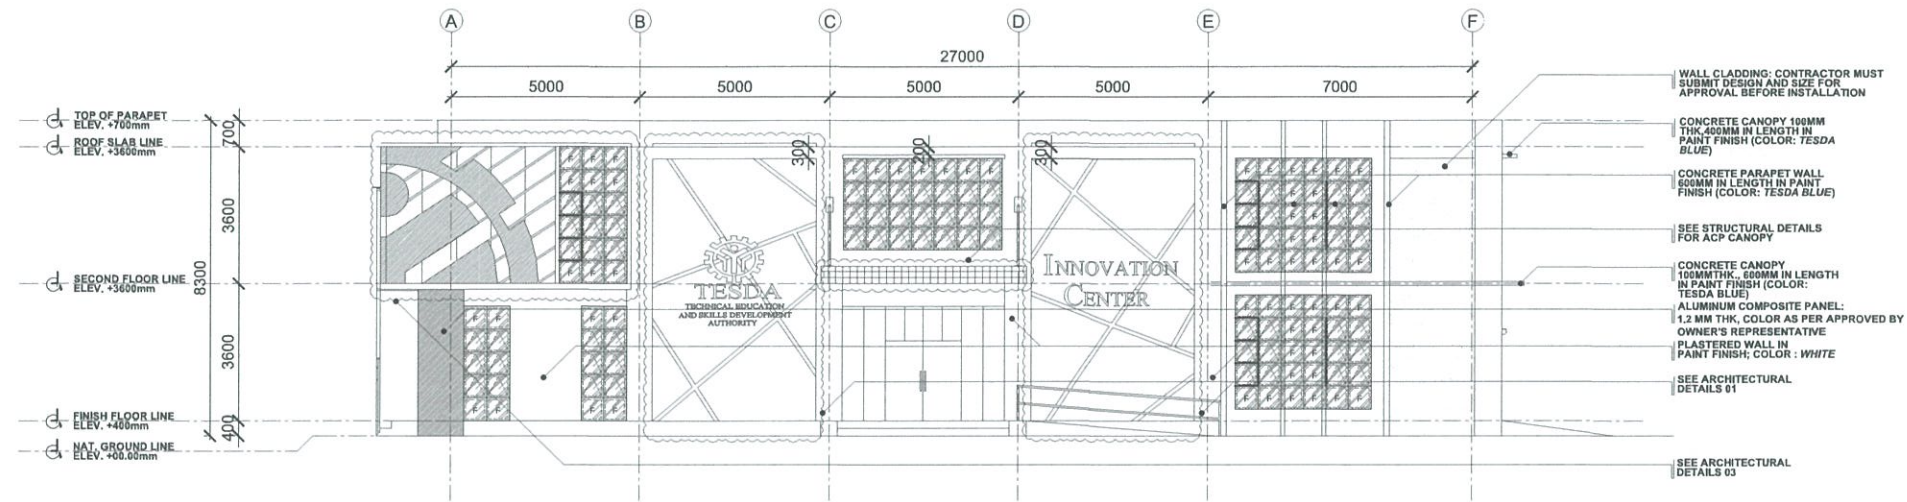

A TESDA INNOVATION CENTER - SOCCSKSARGEN
FRONT ELEVATION
 SCALE 1:200 MTS

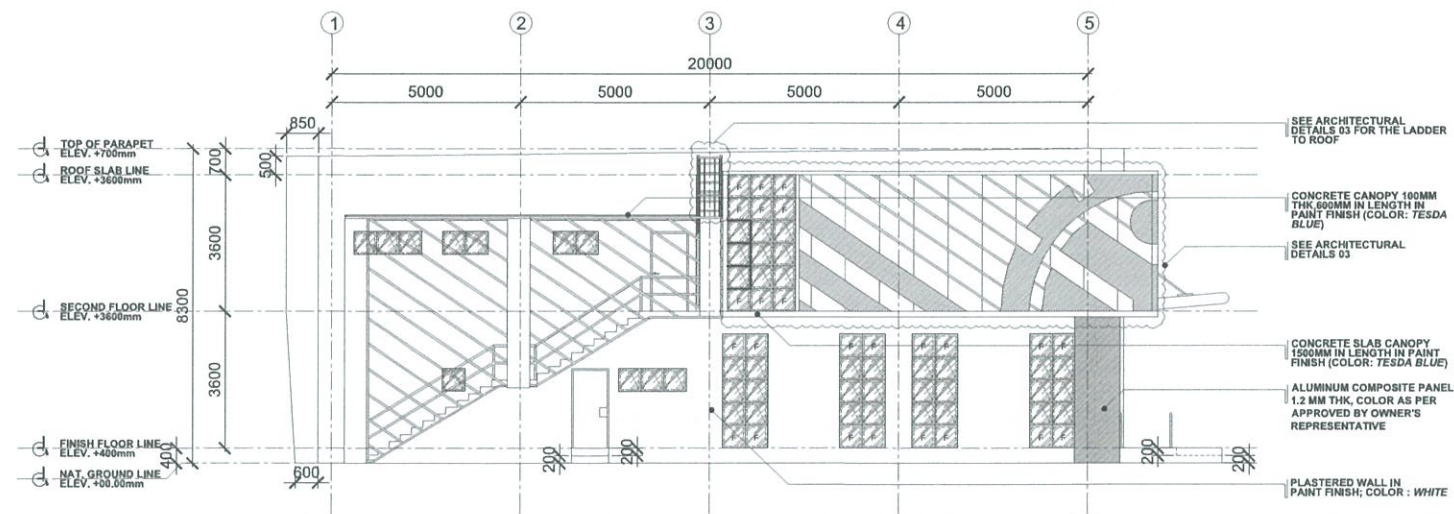

A TESDA INNOVATION CENTER - SOCCSKSARGEN
LEFT SIDE ELEVATION
 SCALE 1:200 MTS

**FOR APPROVAL PLANS OF
 REGIONAL TVET INNOVATION
 CENTERS (RTICs) 2023**

PROJECT OWNER:

**TECHNICAL EDUCATION
 AND
 SKILLS DEVELOPMENT
 AUTHORITY**
 MAIN OFFICE ADDRESS: TESDA COMPLEX, East Service Road SLEX, Taguig City

PROJECT TITLE:
**PROPOSED TESDA SOCCSKSARGEN
 INNOVATION CENTER**
 LOCATION: Spring, Alabid City, Saranggani Province

ARCHITECT:

AR. RUIEZ A. MENDOZA
 HEAD, PMU-SIPTVETS
 ENGINEERING SECTION

PROJECT MANAGER:


DIR. ENRICO C. BANARIO
 PMU-SIPTVETS

PROJECT DIRECTOR:


SEC. SUHARTO T. MANGUDADATU, Ph.D.
 PMU-SIPTVETS
 SECRETARY, TESDA

SHEET CONTENTS:
 FRONT ELEVATION
 LEFT SIDE ELEVATION

SHEET NO.
A-4

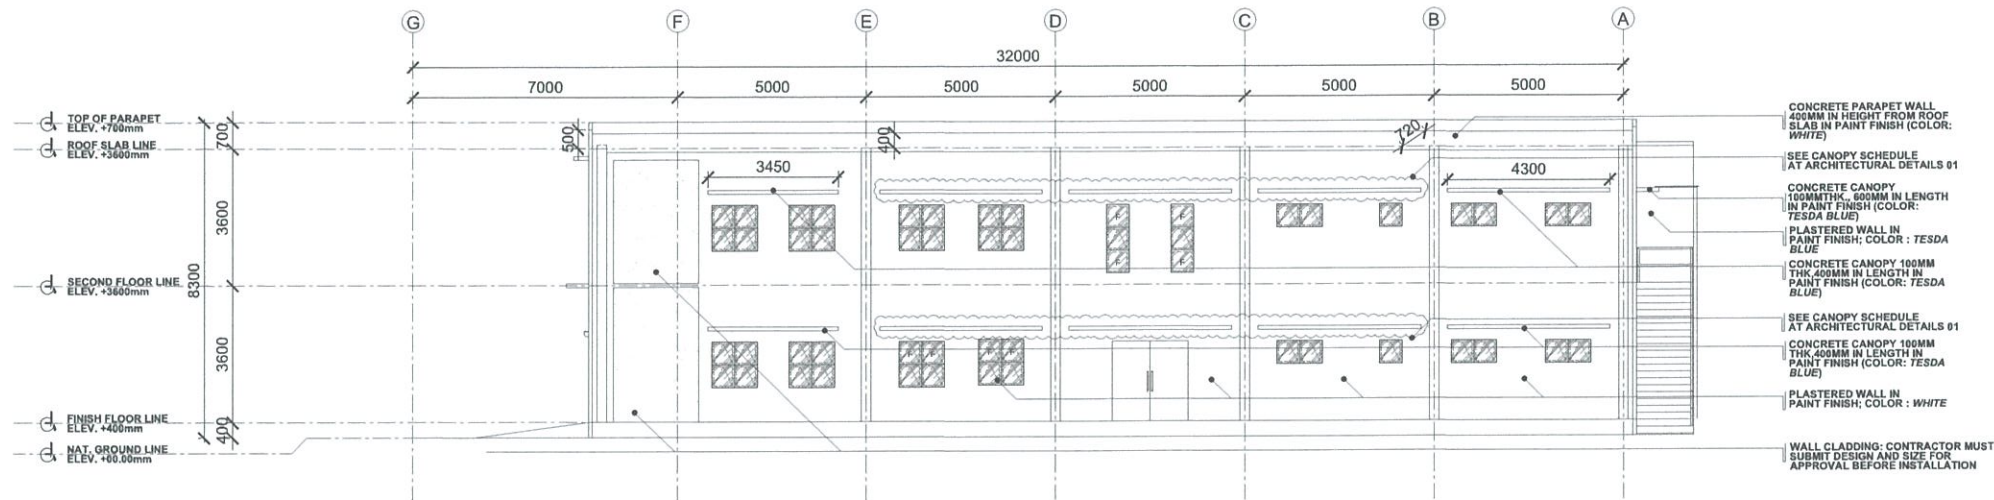

A TESDA INNOVATION CENTER - SOCCSKSARGEN
REAR ELEVATION
SCALE 1:200 MTS

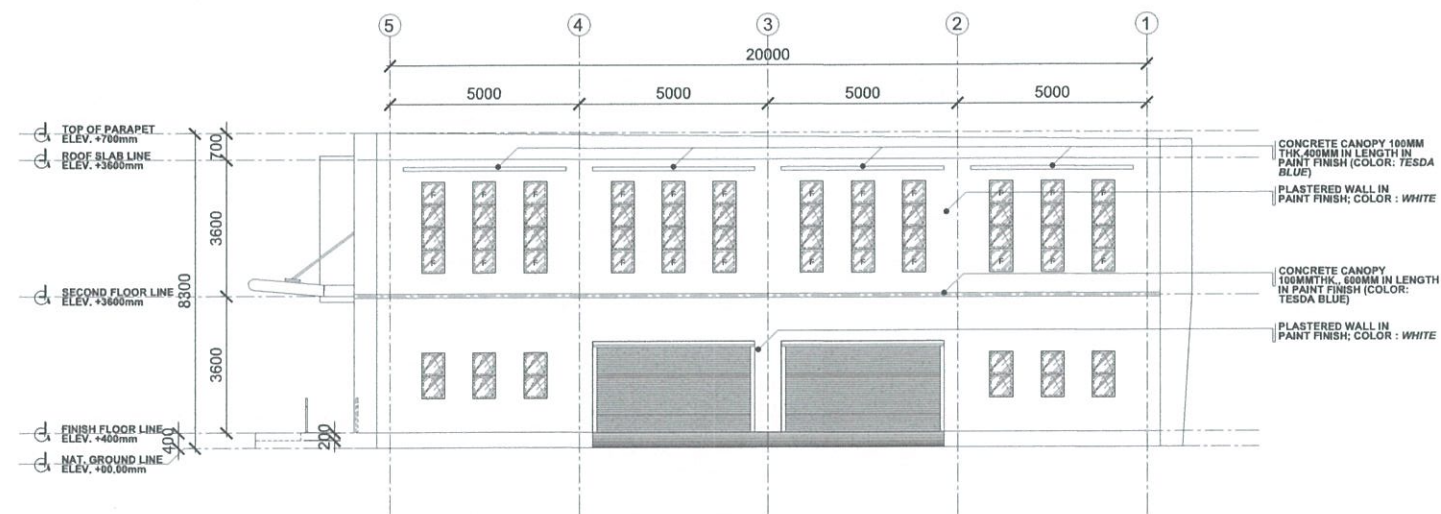

A TESDA INNOVATION CENTER - SOCCSKSARGEN
RIGHT SIDE ELEVATION
SCALE 1:200 MTS

**FOR APPROVAL PLANS OF
REGIONAL TVET INNOVATION
CENTERS (RTICs) 2023**



**TECHNICAL EDUCATION
AND
SKILLS DEVELOPMENT
AUTHORITY**

MAIN OFFICE ADDRESS: TESDA COMPLEX, East Service Road SLEX, Taguig City

PROJECT TITLE:

**PROPOSED TESDA SOCCSKSARGEN
INNOVATION CENTER**

LOCATION: Spring, Alabid City, Saranggani Province

ARCHITECT:

AR. RUIEL A. MENDOZA
HEAD, PMU-SIPTVETS
ENGINEERING SECTION

PROJECT MANAGER:

DIR. ENRICO C. BANARIO
PMU-SIPTVETS


PROJECT DIRECTOR:

SEC. SUHARTO T. MANGUDADATU, Ph.D.
PMU-SIPTVETS
SECRETARY, TESDA


SHEET CONTENTS:
REAR ELEVATION
RIGHT SIDE ELEVATION

SHEET NO.


A-5

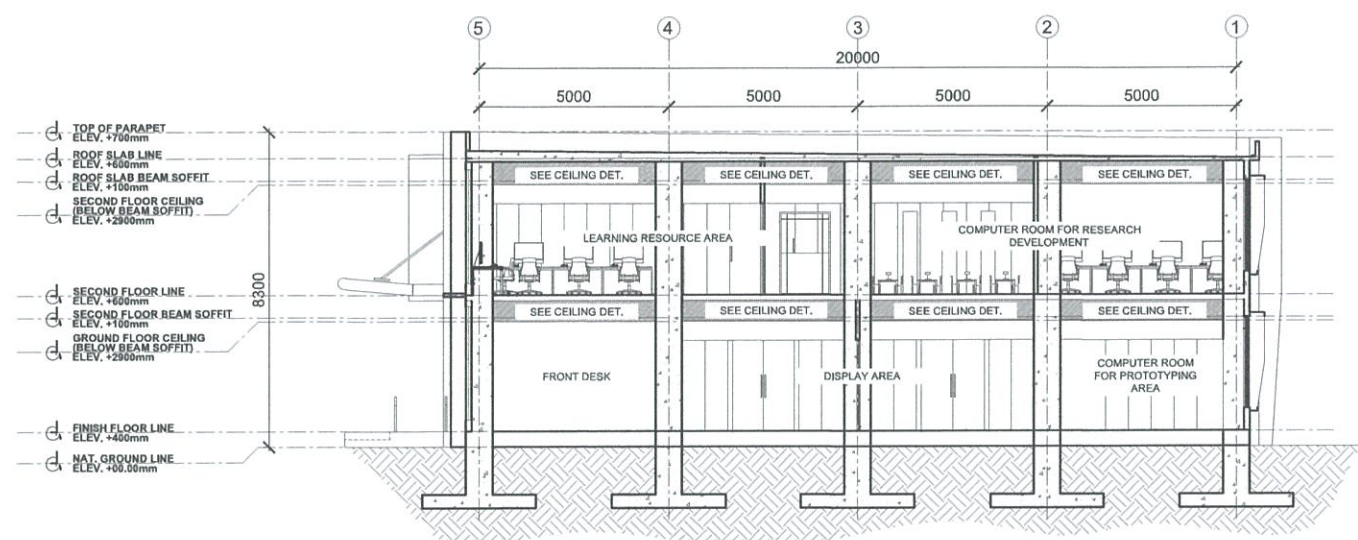

A TESDA INNOVATION CENTER - SOCCSKSARGEN
SECTION THRU A
SCALE 1:200 MTS

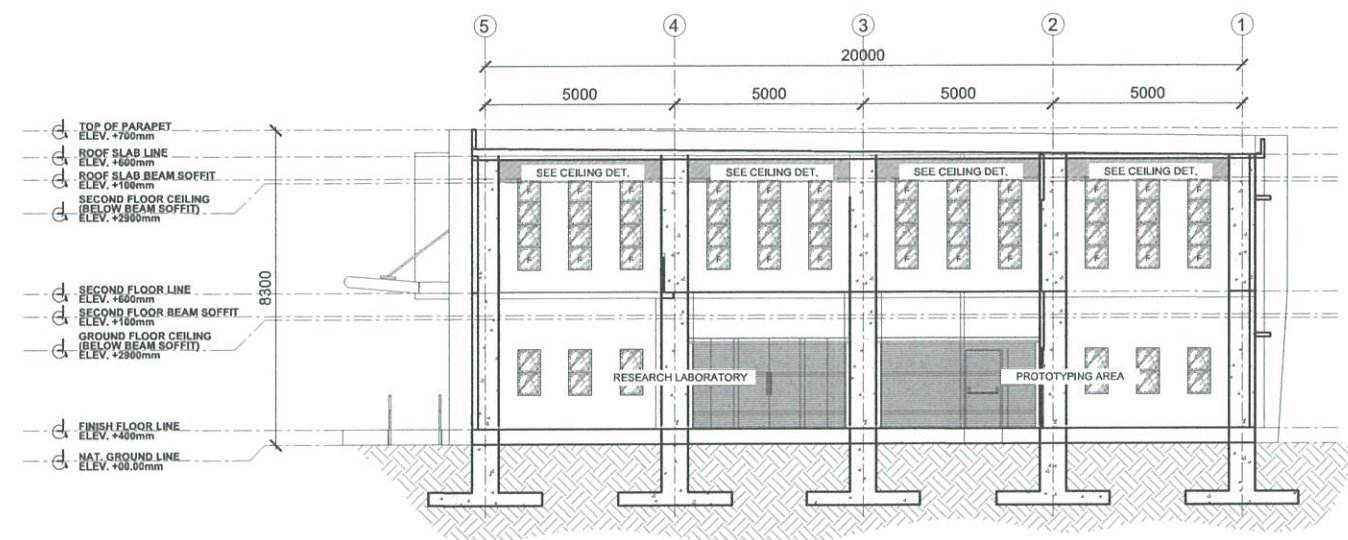

A TESDA INNOVATION CENTER - SOCCSKSARGEN
SECTION THRU B
SCALE 1:200 MTS

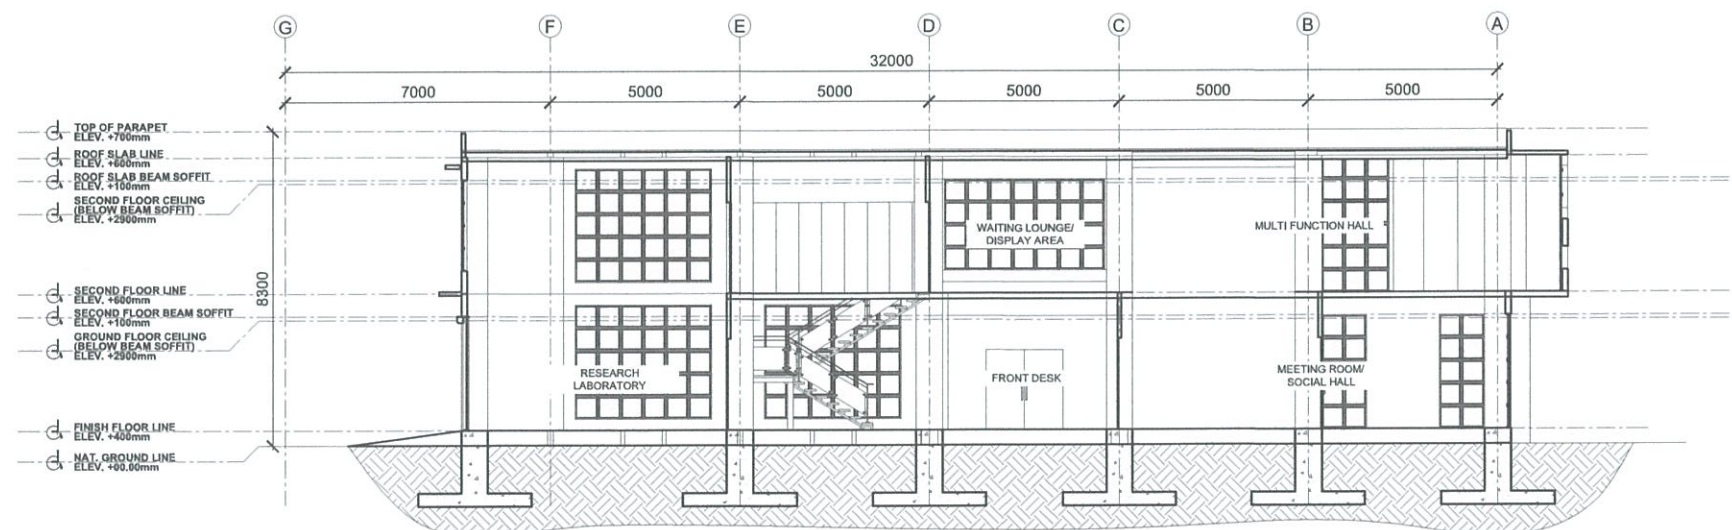

A TESDA INNOVATION CENTER - SOCCSKSARGEN
SECTION THRU C
SCALE 1:200 MTS

**FOR APPROVAL PLANS OF
REGIONAL TVET INNOVATION
CENTERS (RTICs) 2023**

PROJECT OWNER:



**TECHNICAL EDUCATION
AND
SKILLS DEVELOPMENT
AUTHORITY**

MAIN OFFICE ADDRESS: TESDA COMPLEX, East Service Road SLEX, Taguig City;

PROJECT TITLE:

**PROPOSED TESDA SOCCSKSARGEN
INNOVATION CENTER**

LOCATION: Spring, Abital City, Sarangani Province

ARCHITECT:

**MR. RUIEL A. MENDOZA
HEAD, PMU-SIPTVETS
ENGINEERING SECTION**

PROJECT MANAGER:

**DIR. ENRICO C. BANARIO
PMU-SIPTVETS**

PROJECT DIRECTOR:

**SEC. SUHARTO T. MANGUDATU, Ph.D.
PMU-SIPTVETS
SECRETARY, TESDA**


SHEET CONTENTS:
SECTION THRU A
SECTION THRU B

SHEET NO.

A-6

WALL FINISHES	
WF-1	PLAIN CEMENT PLASTER IN PAINT FINISH
WF-2	12MM CLEAR TEMPERED GLASS COSTUME SIZE
WF-3	300MM X 600MM GLAZED WALL TILES (HEIGHT 1.80 M)
WF-4	PLAIN CEMENT FINISH WITH WATER PROOFING (SEE MATERIAL SPECIFICATIONS)
FLOOR FINISHES	
FF-1	600 MM X 600 MM UNGLAZED TILES (COLOR: PORCELAIN WHITE)
FF-2	600 MM X 600 MM UNGLAZED TILES (COLOR: AS PER APPROVED BY OWNER'S REP)
FF-3	PLAIN CEMENT FINISH IN EPOXY PRIMER (COLOR: GRAY)
FF-4	PLAIN CEMENT FINISH WITH WATER PROOFING (SEE MATERIAL SPECIFICATIONS)
FF-5	STAMP CONCRETE/CONC. FINISH

NOTE: FOR ALL CONCRETE CANOPIES, WATERPROOFING SHALL BE APPLIED BEFORE FINAL PAINTING FINISH

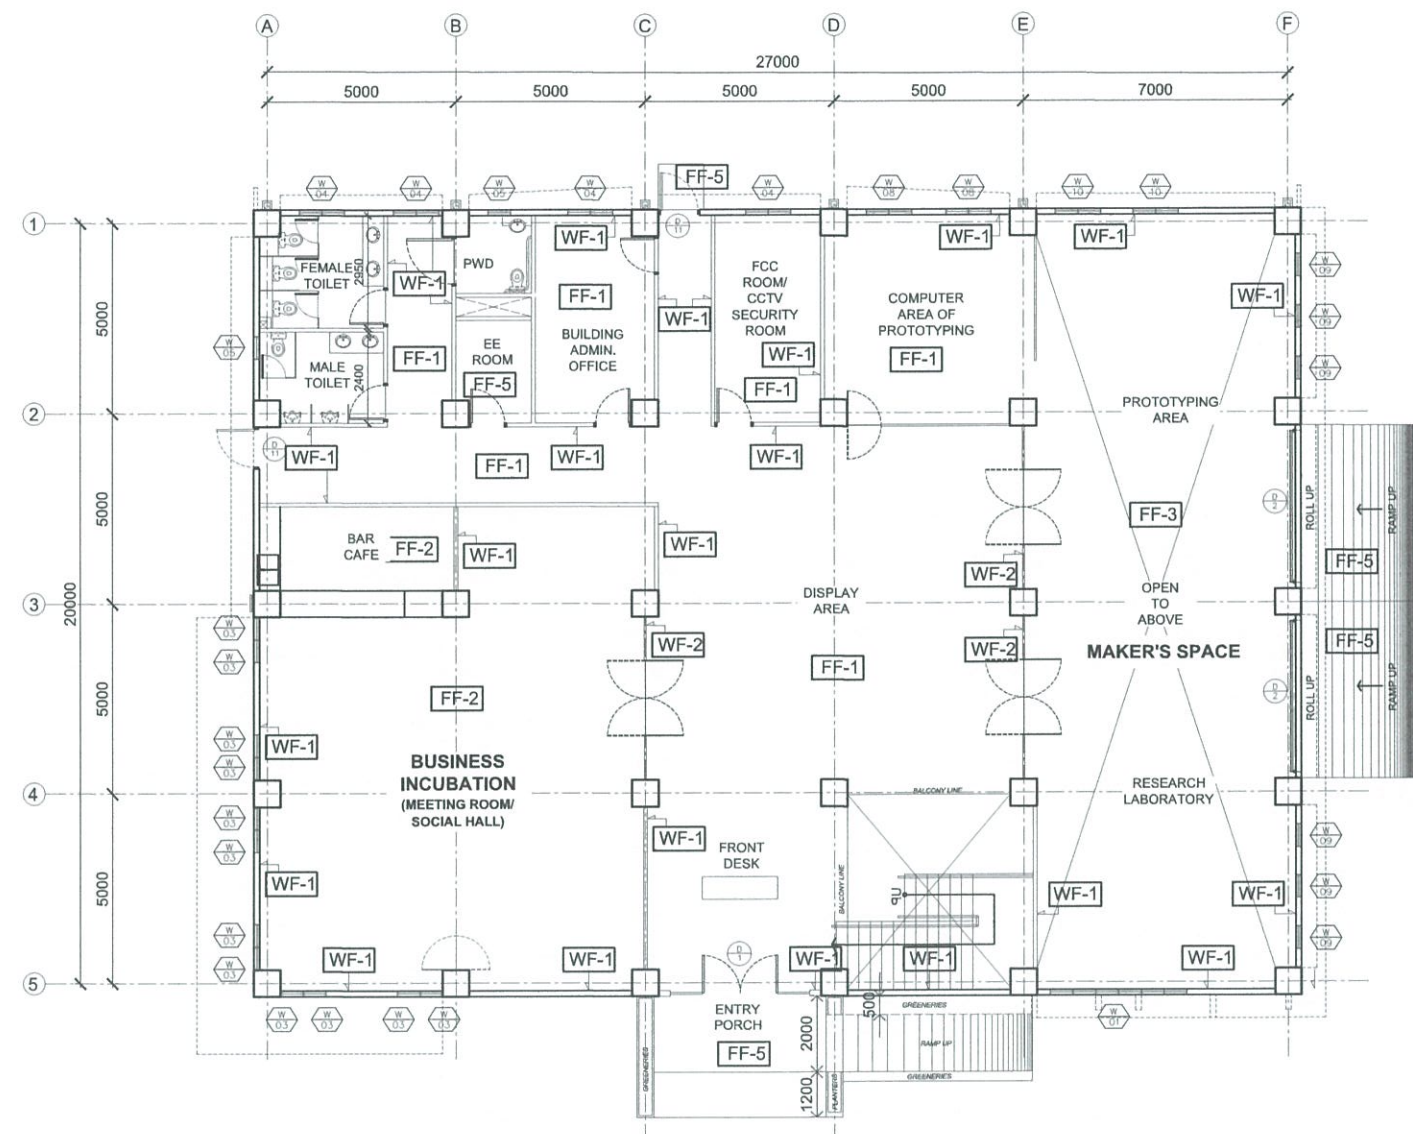


TESDA INNOVATION CENTER - SOCCSKSARGEN
A GROUND FLOOR FINISHES PLAN
 SCALE 1:200 MTS

FOR APPROVAL PLANS OF REGIONAL TVET INNOVATION CENTERS (RTICs) 2023		PROJECT OWNER:	PROJECT TITLE:	ARCHITECT:	PROJECT MANAGER:	PROJECT DIRECTOR:	SHEET CONTENTS:	SHEET NO.
		 TECHNICAL EDUCATION AND SKILLS DEVELOPMENT AUTHORITY MAIN OFFICE ADDRESS: TESDA COMPLEX, East Service Road SLEX, Taguig City	PROPOSED TESDA SOCCSKSARGEN INNOVATION CENTER LOCATION: Spring, Alabid City, Sarangani Province	 AR. RUEL A. MENDOZA HEAD, PMU-SIPTVETS ENGINEERING SECTION	 DIR. ENRIC C. BANARIO PMU-SIPTVETS	 SEC. SUHARTO T. MANGUDADATU, Ph.D. PMU-SIPTVETS SECRETARY, TESDA	GROUND FLOOR FINISHES PLAN	A-7


WALL FINISHES	
WF-1	PLAIN CEMENT PLASTER IN PAINT FINISH
WF-2	12MM CLEAR TEMPERED GLASS COSTUME SIZE
WF-3	300MM X 600MM GLAZED WALL TILES (HEIGHT 1.80 M)
WF-4	PLAIN CEMENT FINISH WITH WATER PROOFING (SEE MATERIAL SPECIFICATIONS)

FLOOR FINISHES	
FF-1	600 MM X 600 MM UNGLAZED TILES (COLOR: PORCELAIN WHITE)
FF-2	600 MM X 600 MM UNGLAZED TILES (COLOR: AS PER APPROVED BY OWNER'S REP)
FF-3	PLAIN CEMENT FINISH IN EPOXY PRIMER (COLOR: GRAY)
FF-4	PLAIN CEMENT FINISH WITH WATER PROOFING (SEE MATERIAL SPECIFICATIONS)
FF-5	STAMP CONCRETE/CONC. FINISH

NOTE: FOR ALL CONCRETE CANOPIES, WATERPROOFING SHALL BE APPLIED BEFORE FINAL PAINTING FINISH

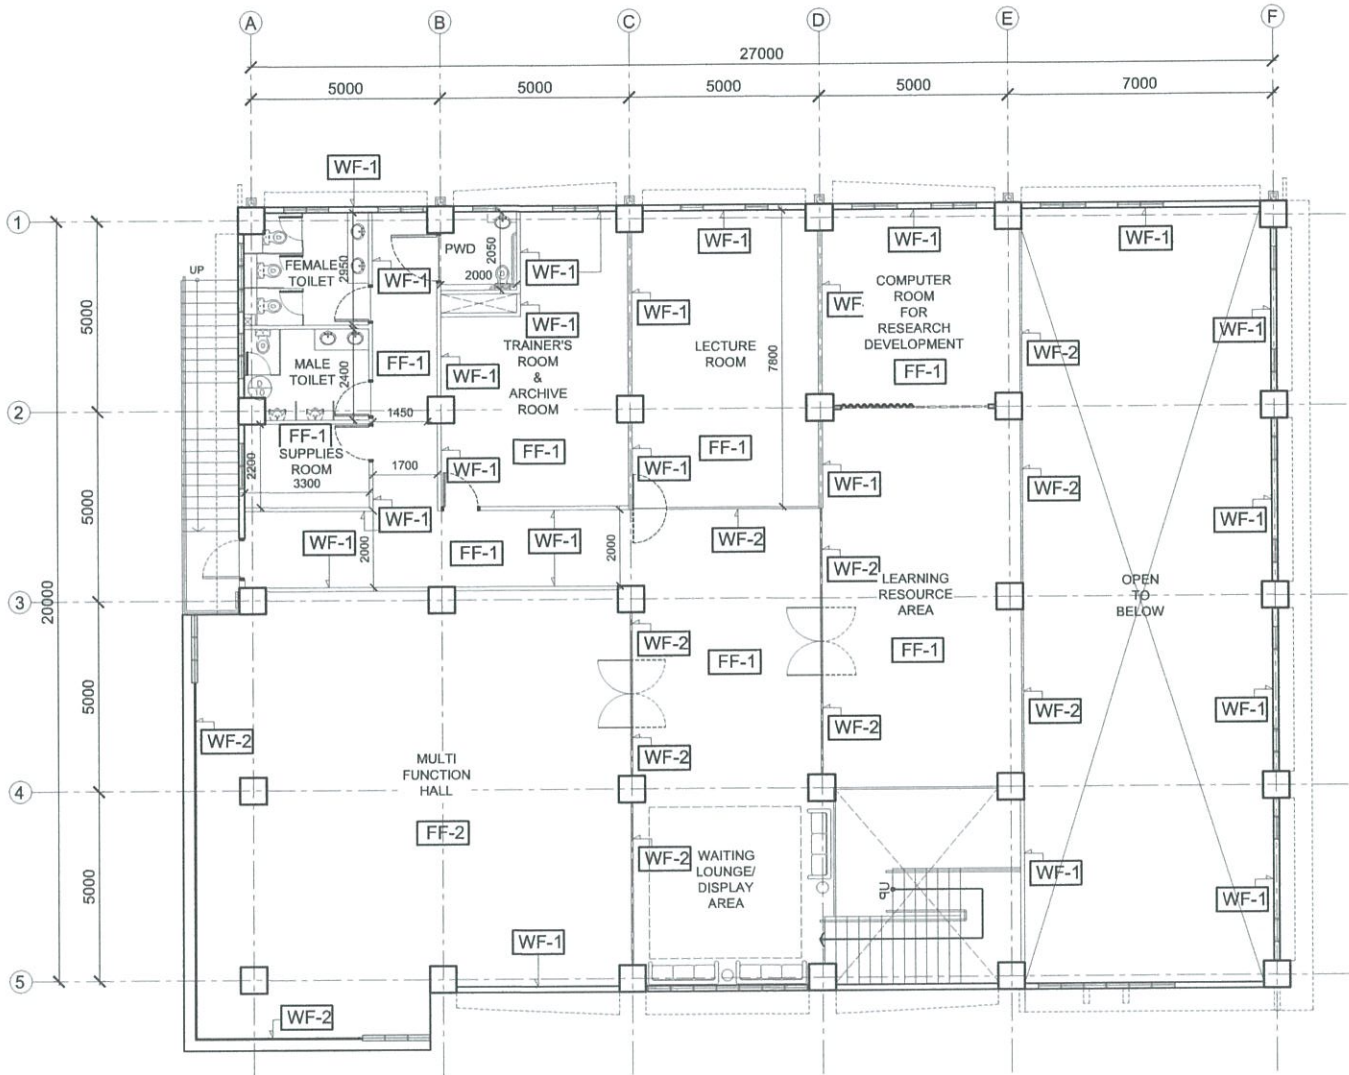

 A TESDA INNOVATION CENTER - SOCCSKSARGEN
SECOND FLOOR FINISHES PLAN
 SCALE 1:200 MTS

FOR APPROVAL PLANS OF REGIONAL TVET INNOVATION CENTERS (RTICs) 2023	PROJECT OWNER:  TECHNICAL EDUCATION AND SKILLS DEVELOPMENT AUTHORITY	PROJECT TITLE: PROPOSED TESDA SOCCSKSARGEN INNOVATION CENTER	ARCHITECT:  AR. RUMI A. MENDOZA HEAD, PMU-SIPTVETS ENGINEERING SECTION	PROJECT MANAGER:  DIR. ENRIC C. BANARIO PMU-SIPTVETS	PROJECT DIRECTOR:  SEC. SUHARTO T. MANGUDADATU, Ph.D. PMU-SIPTVETS SECRETARY, TESDA	SHEET CONTENTS: SECOND FLOOR FINISHES PLAN	SHEET NO. A-8
	MAIN OFFICE ADDRESS: TESDA COMPLEX, East Service Road SLEX, Taguig City	LOCATION: Spring, Alabul City, Sarangani Province					

WF-1	PLAIN CEMENT PLASTER IN PAINT FINISH
WF-2	12MM CLEAR TEMPERED GLASS COSTUME SIZE
WF-3	300MM X 600MM GLAZED WALL TILES (HEIGHT 1.80 M)
WF-4	PLAIN CEMENT FINISH WITH WATER PROOFING (SEE MATERIAL SPECIFICATIONS)

FF-1	600 MM X 600 MM UNGLAZED TILES (COLOR: PORCELAIN WHITE)
FF-2	600 MM X 600 MM UNGLAZED TILES (COLOR: AS PER APPROVED BY OWNER'S REP)
FF-3	PLAIN CEMENT FINISH IN EPOXY PRIMER (COLOR: GRAY)
FF-4	PLAIN CEMENT FINISH WITH WATER PROOFING (SEE MATERIAL SPECIFICATIONS)
FF-5	STAMP CONCRETE/CONC. FINISH

Architectural floor plan of a rectangular building. The plan is defined by a grid system with horizontal lines labeled A through F and vertical lines labeled 1 through 5. The horizontal dimensions are 5000, 5000, 5000, 5000, and 7000, totaling 27000. The vertical dimensions are 5000, 5000, 5000, and 5000, totaling 20000. The plan shows a central area with two triangles and a central label 'FF-4'. The perimeter is lined with 'WF-4' (window frame) symbols. A horizontal line of dots runs across the middle. A note on the right indicates 'DRIP MOULD 25MM'.

TESDA INNOVATION CENTER - SOCCSKSARGEN
ROOF SLAB FLOOR FINISHES PLAN
 SCALE 1:200 MTS


HEET NO.

A-9

LEGENDS AND SYMBOLS	
	RECESSED MOUNTED, 13W LED DOWNLIGHT
	RECESSED MOUNTED, 26W LED DOWNLIGHT
	SURFACE MOUNTED, 1200mm, 20W LED FLUORESCENT LIGHT
	2x20W, 300mmx1200mm, CEILING RECESSED FLUORESCENT LIGHTING FIXTURE WITH ACRYLIC DIFFUSER
	PENDANT LIGHTING FIXTURE
	TWIN-HEAD EMERGENCY LIGHT WITH 2HRS BATTERY BACK
	8W EXIT LIGHT WITH 2HRS BATTERY PACK
	13W SUSPENDED LINEAR LIGHT
	CONCEALED LIGHTING
	1 GANG, SINGLE POLE SINGLE THROW SWITCH, 15A, 230V
	2 GANG, SINGLE POLE SINGLE THROW SWITCH, 15A, 230V
	3 GANG, SINGLE POLE SINGLE THROW SWITCH, 15A, 230V
	RISER UP/DOWN
	JUNCTION BOX (CONCEALED LIGHTING PROVISION/TAPPING POINT)

CEILING FINISHES	
CF-1	ACOUSTICAL PANEL CEILING FRAMED WITH METAL FRAMING SYSTEM PAINTED COLOR AS PER APPROVED
CF-2	HARDIFLEX CEILING FRAMED WITH METAL FRAMING SYSTEM PAINTED COLOR AS PER APPROVED
CF-3	SLAB/BEAM SOFFIT PLASTERED FINISH PAINTED MATTE BLACK
CF-4	SLAB/BEAM SOFFIT PLASTERED FINISH NO PAINT
CF-5	ALUMINUM COMPOSITE PANEL INSTALLED GRAY FINISH; PROVIDE SAMPLE FOR INSTALLATION APPROVAL

NOTE: FOR ALL ELECTRICAL FIXTURES, ELECTRICAL PLANS SHALL GOVERN UPON DEFINITE LOCATION.

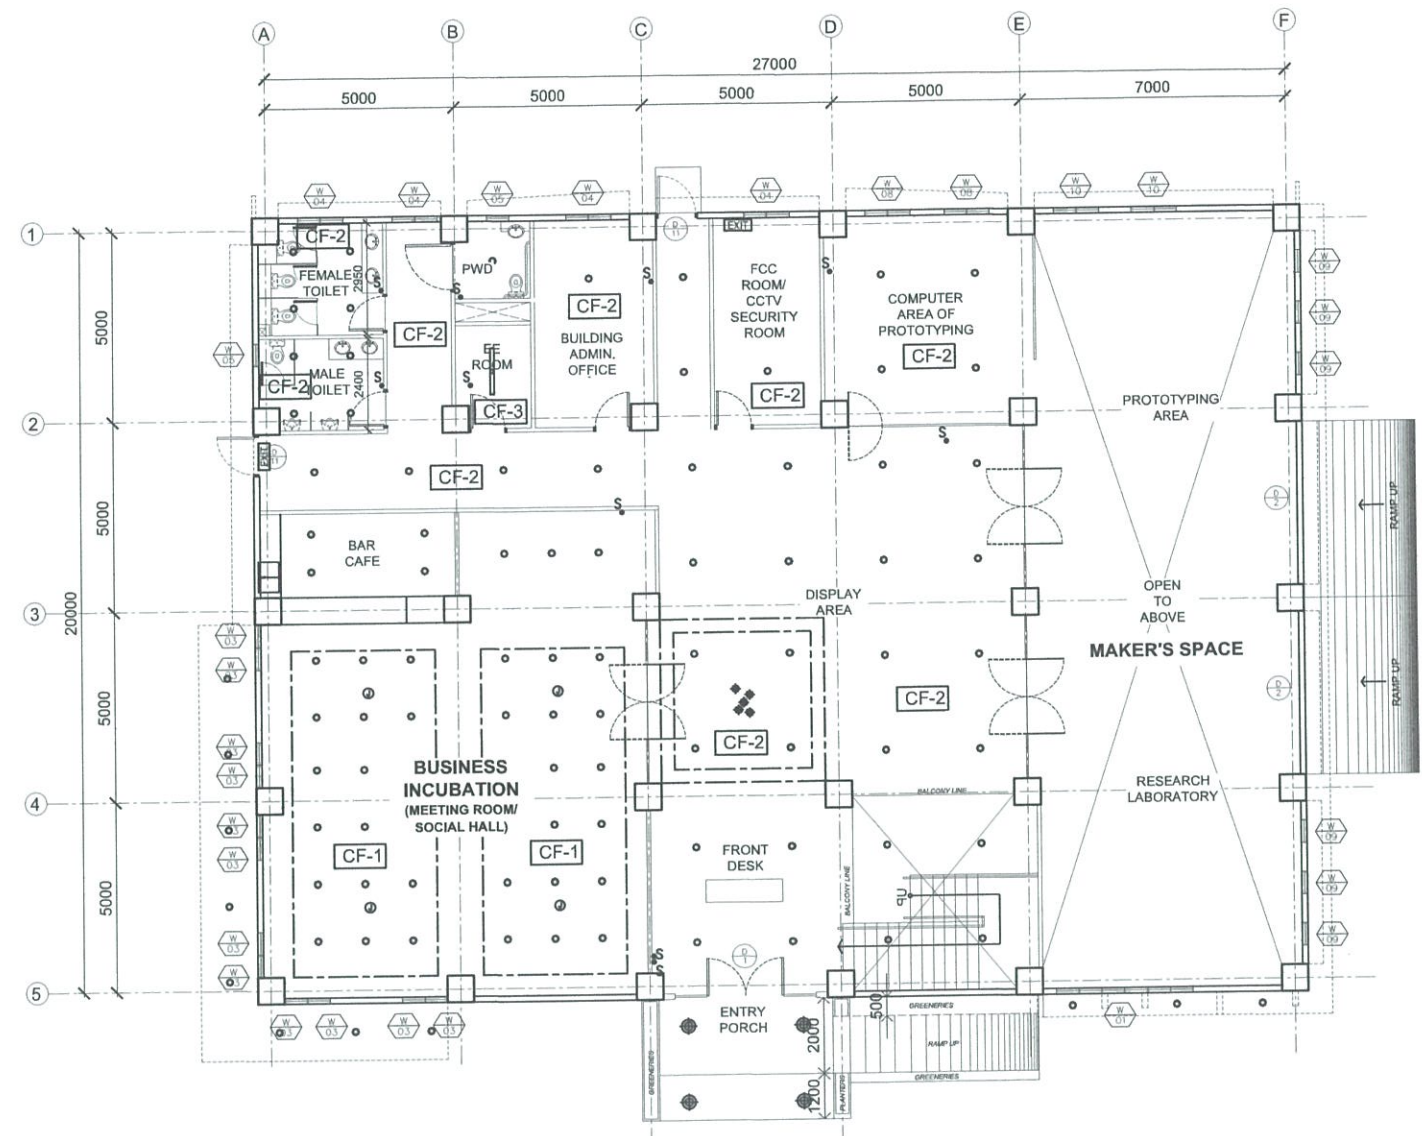


TESDA INNOVATION CENTER - SOCCSKSARGEN
A GROUND FLOOR REFLECTED CEILING PLAN
SCALE 1:200 MTS

FOR APPROVAL PLANS OF REGIONAL TVET INNOVATION CENTERS (RTICs) 2023	PROJECT OWNER: TECHNICAL EDUCATION AND SKILLS DEVELOPMENT AUTHORITY	PROJECT TITLE: PROPOSED TESDA SOCCSKSARGEN INNOVATION CENTER	ARCHITECT: AR. RANIEL A. MENDOZA HEAD, PMU-SIPTVETS ENGINEERING SECTION	PROJECT MANAGER: DIR. ENRICO C. BANARIO PMU-SIPTVETS	PROJECT DIRECTOR: SEC. SUHARTO T. MANGUDADATU, Ph.D. PMU-SIPTVETS SECRETARY, TESDA	SHEET CONTENTS: GROUND FLOOR REFLECTED CEILING PLAN	SHEET NO. A-10
	MAIN OFFICE ADDRESS: TESDA COMPLEX, East Service Road SLEX, Taguig City.	LOCATION: Spring, Alindog City, Saranggani Province					

LEGENDS AND SYMBOLS	
	RECESSED MOUNTED, 13W LED DOWNLIGHT
	RECESSED MOUNTED, 26W LED DOWNLIGHT
	SURFACE MOUNTED, 1200mm, 20W LED FLUORESCENT LIGHT
	2x20W, 300mmx1200mm, CEILING RECESSED FLUORESCENT LIGHTING FIXTURE WITH ACRYLIC DIFFUSER
	PENDANT LIGHTING FIXTURE
	TWIN-HEAD EMERGENCY LIGHT WITH 2HRS BATTERY BACK
	8W EXIT LIGHT WITH 2HRS BATTERY PACK
	13W SUSPENDED LINEAR LIGHT
	CONCEALED LIGHTING
	1 GANG, SINGLE POLE SINGLE THROW SWITCH, 15A, 230V
	2 GANG, SINGLE POLE SINGLE THROW SWITCH, 15A, 230V
	3 GANG, SINGLE POLE SINGLE THROW SWITCH, 15A, 230V
	RISER UP/DOWN
	JUNCTION BOX (CONCEALED LIGHTING PROVISION/TAPPING POINT)

CEILING FINISHES	
CF-1	ACOUSTICAL PANEL CEILING FRAMED WITH METAL FRAMING SYSTEM PAINTED COLOR AS PER APPROVED
CF-2	HARDIFLEX CEILING FRAMED WITH METAL FRAMING SYSTEM PAINTED COLOR AS PER APPROVED
CF-3	SLAB/BEAM SOFFIT PLASTERED FINISH PAINTED MATTE BLACK
CF-4	SLAB/BEAM SOFFIT PLASTERED FINISH NO PAINT
CF-5	ALUMINUM COMPOSITE PANEL INSTALLED GRAY FINISH; PROVIDE SAMPLE FOR INSTALLATION APPROVAL

NOTE: FOR ALL ELECTRICAL FIXTURES, ELECTRICAL PLANS SHALL GOVERN UPON DEFINITE LOCATION.

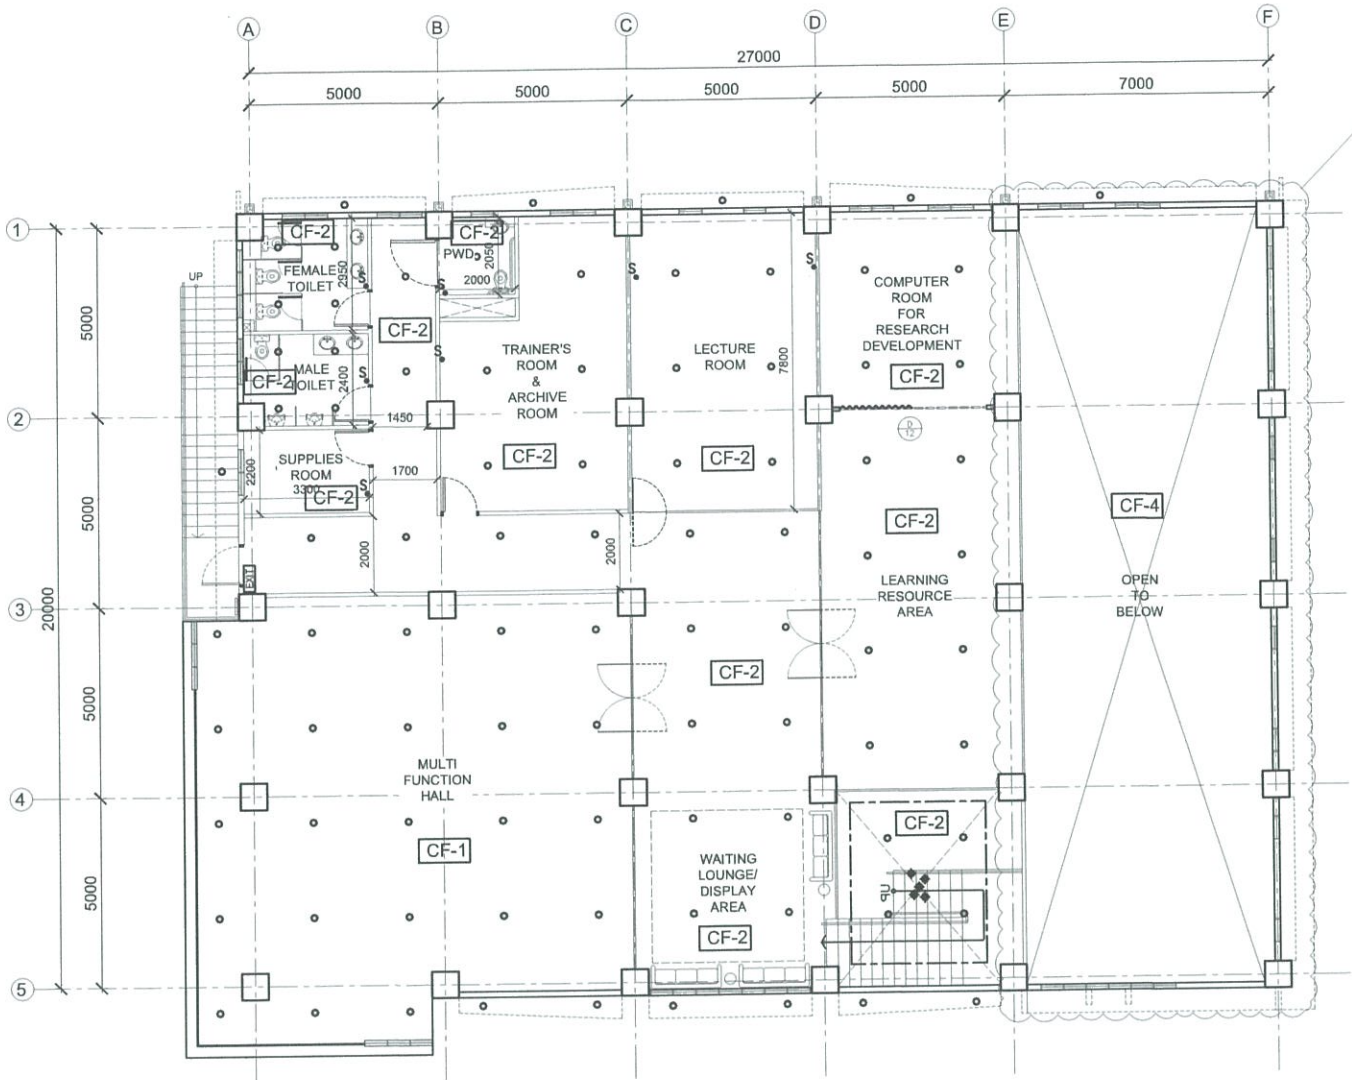

TESDA INNOVATION CENTER - SOCCSKSARGEN
SECOND FLOOR REFLECTED CEILING PLAN
SCALE 1:200 MTS

FOR APPROVAL PLANS OF
REGIONAL TVET INNOVATION
CENTERS (RTICs) 2023



MAIN OFFICE ADDRESS: TESDA COMPLEX, East Service Road SLEX, Taguig City.

PROJECT TITLE:
**PROPOSED TESDA SOCCSKSARGEN
INNOVATION CENTER**

LOCATION: Spring, Abulid City, Sarangani Province

ARCHITECT:

AR. RANIEL A. MENDOZA
HEAD, PMU-SIPTVETS
ENGINEERING SECTION

PROJECT MANAGER:


DIR. ENRICO C. BANARIO
PMU-SIPTVETS

PROJECT DIRECTOR:


SEC. SUHARTO T. MANGUDADATU, Ph.D.
PMU-SIPTVETS
SECRETARY, TESDA

SHEET CONTENTS:
SECOND FLOOR REFLECTED
CEILING PLAN

SHEET NO.
A-11

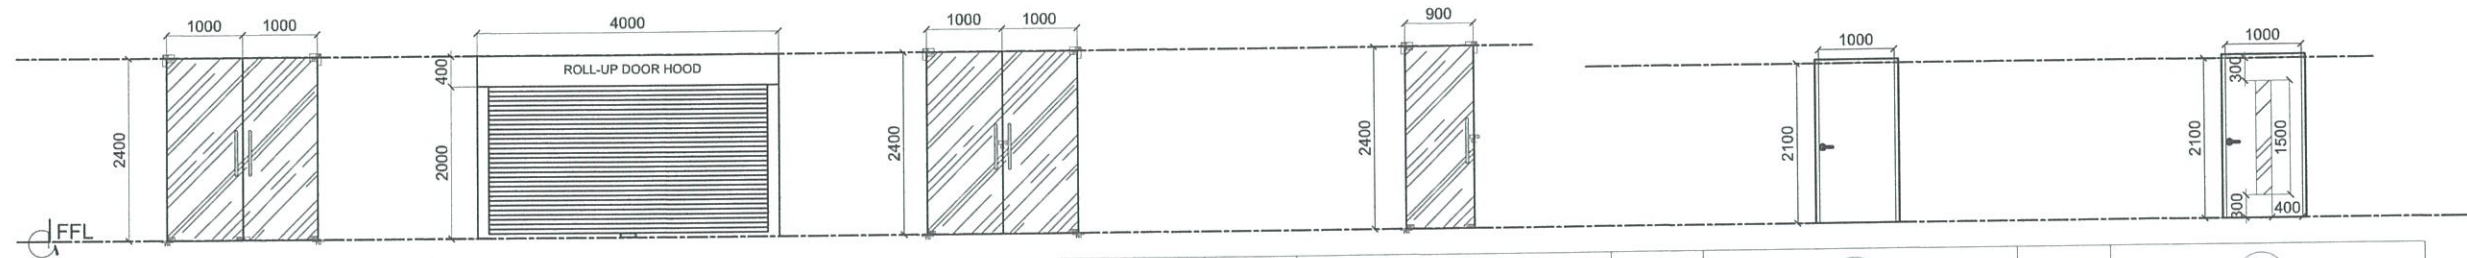

SCHEDULE	D 01	SCHEDULE	D 02	SCHEDULE	D 03	SCHEDULE	D 04	SCHEDULE	D 05	SCHEDULE	D 06
LOCATION:	MAIN ENTRANCE/EXIT AND REAR ENTRANCE/EXIT	LOCATION:	PROTOTYPING AREA	LOCATION:	BUSINESS INCUBATION AREA, PROTOTYPING, RESEARCH LABORATORY AND MULTIFUNCTION HALL	LOCATION:	COMPUTER ROOMS FOR PROTOTYPING & RESEARCH AREA AND LECTURE ROOM	LOCATION:	TRAINER'S ROOM & ARCHIVE AND SUPPLIES ROOM	LOCATION:	FCC ROOM/CCTV SECURITY ROOM AND BUILDING ADMIN OFFICE
DIMENSION	2400mm (H) x 1000mm (W) X 12mm (THK) PER LEAF	DIMENSION	2400mm (H) x 4000mm (W)	DIMENSION	2400mm (H) x 1000mm (W) X 12mm (THK) PER LEAF	DIMENSION	2400mm (H) x 900mm (W) X 12mm (THK) PER LEAF	DIMENSION	2100mm (H) x 1000mm (W) X 50mm (THK) PER LEAF	DIMENSION	2100mm (H) x 1000mm (W) X 50mm (THK) PER LEAF
DESCRIPTION:	DOUBLE SWING GLASS DOOR, WITH BOTTOM PATCH LOCK, COMPLETE FITTINGS: TOP, BOTTOM & CORNER PATCH AND FLOOR HINGES; STAINLESS STEEL FINISH, H-TYPE HANDLE SET; 600mm LENGTH, 25MM DIAMETER, STAINLESS STEEL MATERIAL POLISHED CHROME FINISH. CLEAR DIMENSION FOR ACTUAL WILL GOVERN PRIOR FOR INSTALLATION.	DESCRIPTION:	STAINLESS STEEL SHUTTER/ROLL-UP DOOR, WITH BOX COVER; MANUAL TYPE WITH BOTTOM CLAMP FOR LOCK.	DESCRIPTION:	DOUBLE SWING GLASS DOOR, WITH GLASS LOCK, COMPLETE FITTINGS: TOP, BOTTOM & CORNER PATCH AND FLOOR HINGES; STAINLESS STEEL FINISH, H-TYPE HANDLE SET; 600mm LENGTH, 25MM DIAMETER, STAINLESS STEEL MATERIAL POLISHED CHROME FINISH. CLEAR DIMENSION FOR ACTUAL WILL GOVERN PRIOR FOR INSTALLATION.	DESCRIPTION:	SINGLE SWING GLASS DOOR, WITH GLASS LOCK, COMPLETE FITTINGS: TOP, BOTTOM & CORNER PATCH AND FLOOR HINGES; STAINLESS STEEL FINISH, H-TYPE HANDLE SET; 600mm LENGTH, 25MM DIAMETER, STAINLESS STEEL MATERIAL POLISHED CHROME FINISH. CLEAR DIMENSION FOR ACTUAL WILL GOVERN PRIOR FOR INSTALLATION.	DESCRIPTION:	SINGLE SWING WOOD PANEL DOOR, WITH LEVER TYPE LOCK, COMPLETE FITTINGS: HINGES, BRASS FINISH, IN A 4" X 2" WOODEN FRAME. CLEAR DIMENSION FOR ACTUAL WILL GOVERN PRIOR FOR INSTALLATION.	DESCRIPTION:	SINGLE SWING WOOD PANEL DOOR, WITH LEVER TYPE LOCK, COMPLETE FITTINGS: HINGES, BRASS FINISH, IN A 4" X 2" WOODEN FRAME AND WITH CLEAR GLASS PEEP AREA (200mm x 1500mm). CLEAR DIMENSION FOR ACTUAL WILL GOVERN PRIOR FOR INSTALLATION.
NO OF SET:	TWO (2) SET/S	NO OF SET:	TWO (2) SET/S	NO OF SET:	FIVE (5) SET/S	NO OF SET:	TWO (2) SET/S	NO OF SET:	TWO (2) SET/S	NO OF SET:	TWO (2) SET/S

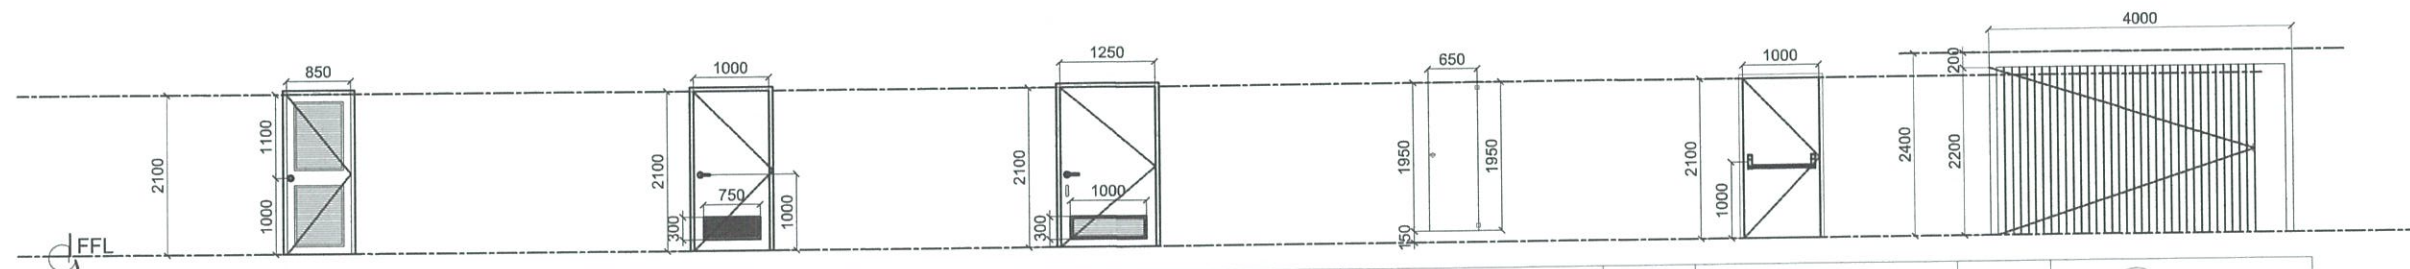

SCHEDULE	D 07	SCHEDULE	D 08	SCHEDULE	D 09	SCHEDULE	D 10	SCHEDULE	D 11	SCHEDULE	D 12
LOCATION:	ELECTRICAL ROOM	LOCATION:	MALE AND FEMALE COMFORT ROOMS	LOCATION:	PWD TOILET ROOM	LOCATION:	MALE AND FEMALE TOILET ROOM	LOCATION:	FIRE EXIT	LOCATION:	LEARNING RESOURCE AREA & PROTOTYPING AREA
DIMENSION	2100mm (H) x 850mm (W) X 50mm (THK) PER LEAF	DIMENSION	2100mm (H) x 850mm (W) X 50mm (THK) PER LEAF	DIMENSION	2100mm (H) x 1250mm (W) x 50mm (THK)	DIMENSION	1950 mm x 2100 mm	DIMENSION	2100mm (H) x 1000mm (W) x 50mm (THK)	DIMENSION	2400mm (H)
DESCRIPTION:	SINGLE SWING METAL LOUVERED DOOR, WITH LEVER TYPE LOCK, COMPLETE FITTINGS: HINGES, BRASS FINISH, IN A 4" X 2" METAL FRAME. CLEAR DIMENSION FOR ACTUAL WILL GOVERN PRIOR FOR INSTALLATION.	DESCRIPTION:	SINGLE SWING UPVC FLUSH DOOR, WITH LEVER TYPE LOCK, COMPLETE FITTINGS: HINGES, BRASS FINISH, IN A 4" X 2" UPVC FRAME. CLEAR DIMENSION FOR ACTUAL WILL GOVERN PRIOR FOR INSTALLATION.	DESCRIPTION:	SINGLE SWING UPVC FLUSH DOOR TYP. HINGED DOOR ON 50 X 150mm PVC JAMB/FRAME WITH LEVER TYPE HANDLE & LOCK SET. 150mm ALUMINUM D-HANDLE. CLEAR DIMENSION FOR ACTUAL WILL GOVERN PRIOR FOR INSTALLATION.	DESCRIPTION:	TOILET PARTITION PLASTIC LAMINATED DOOR WITH STAINLESS LATCH AND TOP & BOTTOM BRACKET CLIPS. CLEAR DIMENSION FOR ACTUAL WILL GOVERN PRIOR FOR INSTALLATION.	DESCRIPTION:	SINGLE SWING PRE-FABRICATED STEEL DOOR TYP. HINGED DOOR ON 50 X 100mm METAL JAMB W/ INTUMESCENT STRIP COLD SMOKE SEAL; W/ PANIC DOOR BAR. CLEAR DIMENSION FOR ACTUAL WILL GOVERN PRIOR FOR INSTALLATION.	DESCRIPTION:	ACCORDION/ FOLDING TYPE DOOR WITH TOP TRACK AND PLASTIC LAMINATED FINISH. CLEAR DIMENSION FOR ACTUAL WILL GOVERN PRIOR FOR INSTALLATION.
NO OF SET:	ONE (1) SET/S	NO OF SET:	FOUR (4) SET/S	NO OF SET:	TWO (2) SET/S	NO OF SET:	EIGHT (8) SET/S	NO OF SET:	TWO (2) SET/S	NO OF SET:	ONE (1) SET/S

A
TESDA INNOVATION CENTER - SOCCSKSARGEN
SCHEDULE OF DOORS
 SCALE 1:100 MTS

**FOR APPROVAL PLANS OF
REGIONAL TVET INNOVATION
CENTERS (RTICs) 2023**



MAIN OFFICE ADDRESS: TESDA COMPLEX, East Service Road BLEX, Taguig City

PROJECT TITLE:
**PROPOSED TESDA SOCCSKSARGEN
INNOVATION CENTER**

LOCATION: Spring, Abul City, Saranggani Province

ARCHITECT:

AR. RUMI A. MENDOZA
HEAD, PMU-SIPTVETS
ENGINEERING SECTION

PROJECT MANAGER:

DIR. ENRIQUE C. BANARIO
PMU-SIPTVETS


PROJECT DIRECTOR:

SEC. SUHARTO T. MANGUDADATU, Ph.D.
PMU-SIPTVETS
SECRETARY, TESDA


SHEET CONTENTS:
SCHEDULE OF DOORS

SHEET NO.

A-12

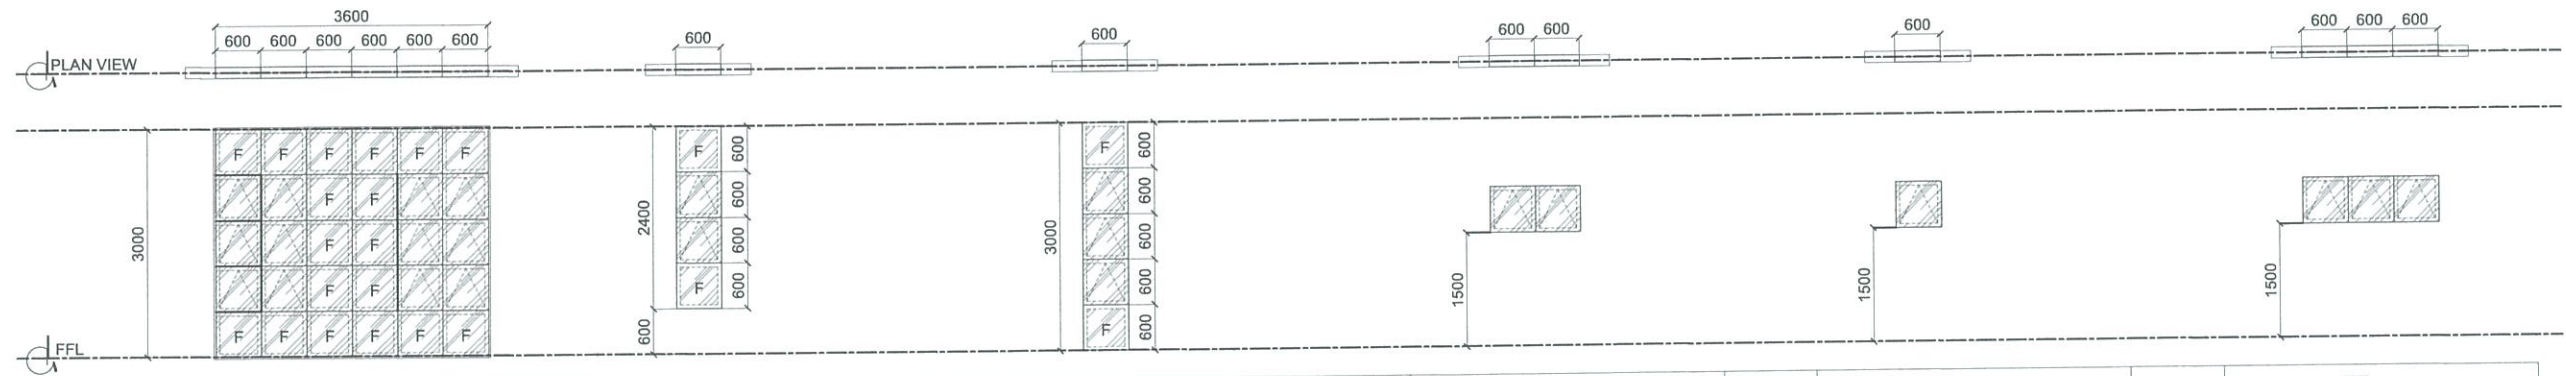

SCHEDULE	W 01	SCHEDULE	W 02	SCHEDULE	W 03	SCHEDULE	W 04	SCHEDULE	W 05	SCHEDULE	W 06
LOCATION:	FRONT FACADE	LOCATION:	RIGHT & REAR VIEWS OF THE BUILDING	LOCATION:	FRONT & LEFT VIEWS OF THE BUILDING	LOCATION:	RIGHT & REAR VIEWS OF THE BUILDING	LOCATION:	RIGHT & REAR VIEWS OF THE BUILDING	LOCATION:	RIGHT SIDE VIEW OF THE BUILDING
DIMENSION	3000mm x 3600mm	DIMENSION	2400mm x 600mm	DIMENSION	3000mm x 600mm	DIMENSION	1200mm x 600mm	DIMENSION	600mm x 600mm	DIMENSION	1800mm x 600mm
DESCRIPTION:	MIXED AWNING & FIXED WINDOW: LOW-E TEMPERED GLASS 6 MM THK, REFLECTIVE FILM INSTALLED, SEALANT ON FRAME & GLASS EDGES; SAMPLE SHOULD BE PROVIDED BEFORE INSTALLATION.	DESCRIPTION:	MIXED AWNING & FIXED WINDOW: LOW-E TEMPERED GLASS 6 MM THK, REFLECTIVE FILM INSTALLED, SEALANT ON FRAME & GLASS EDGES; SAMPLE SHOULD BE PROVIDED BEFORE INSTALLATION.	DESCRIPTION:	MIXED AWNING & FIXED WINDOW: LOW-E TEMPERED GLASS 6 MM THK, REFLECTIVE FILM INSTALLED, SEALANT ON FRAME & GLASS EDGES; SAMPLE SHOULD BE PROVIDED BEFORE INSTALLATION.	DESCRIPTION:	AWNING WINDOW: LOW-E TEMPERED GLASS 6 MM THK, REFLECTIVE FILM INSTALLED, SEALANT ON FRAME & GLASS EDGES; SAMPLE SHOULD BE PROVIDED BEFORE INSTALLATION.	DESCRIPTION:	AWNING WINDOW: LOW-E TEMPERED GLASS 6 MM THK, REFLECTIVE FILM INSTALLED, SEALANT ON FRAME & GLASS EDGES; SAMPLE SHOULD BE PROVIDED BEFORE INSTALLATION.	DESCRIPTION:	AWNING WINDOW: LOW-E TEMPERED GLASS 6 MM THK, REFLECTIVE FILM INSTALLED, SEALANT ON FRAME & GLASS EDGES; SAMPLE SHOULD BE PROVIDED BEFORE INSTALLATION.
NO OF SET:	TWO (2) SET/S	NO OF SET:	EIGHT (8) SET/S	NO OF SET:	TWELVE (12) SET/S	NO OF SET:	NINE (9) SET/S	NO OF SET:	THREE (3) SET/S	NO OF SET:	ONE (1) SET/S

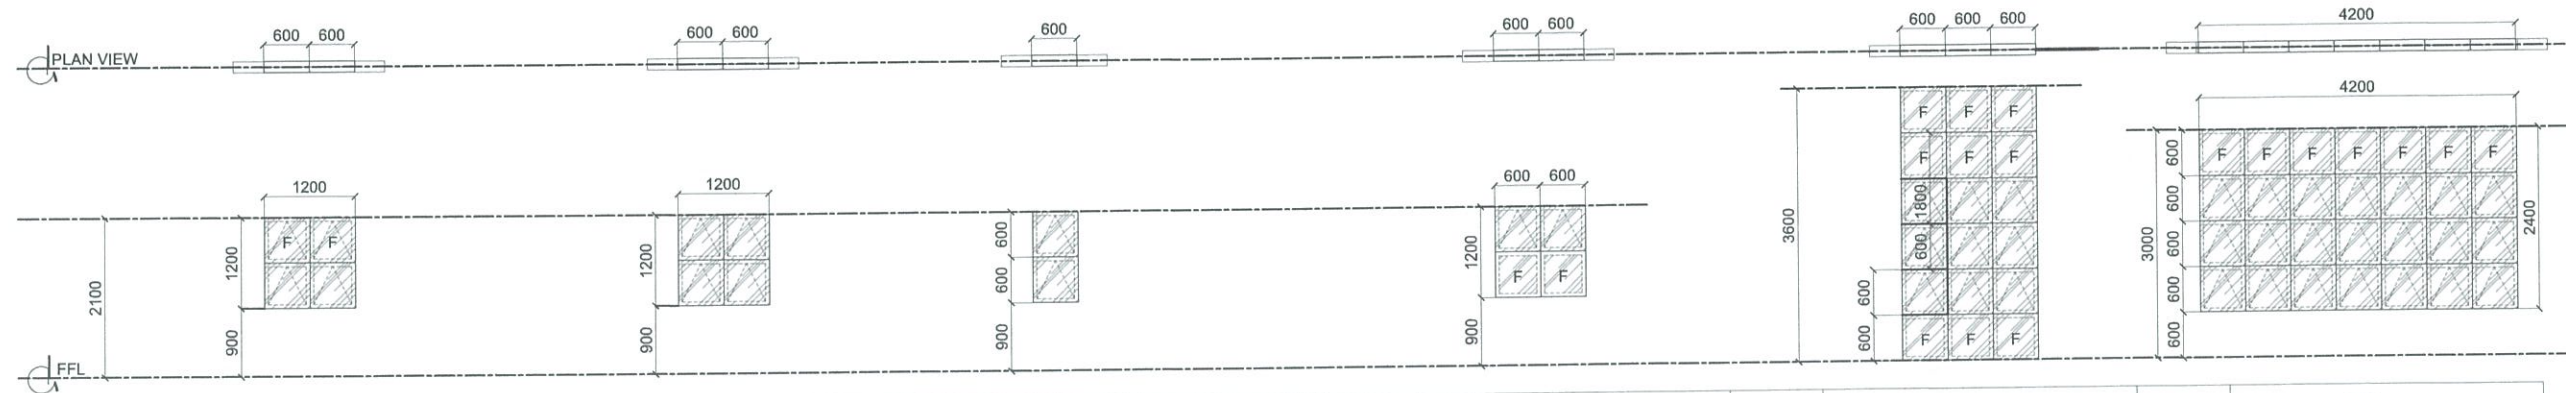

SCHEDULE	W 07	SCHEDULE	W 08	SCHEDULE	W 09	SCHEDULE	W 10	SCHEDULE	W 11	SCHEDULE	W 12
LOCATION:	REAR PART OF THE BUILDING	LOCATION:	REAR PART OF THE BUILDING	LOCATION:	REAR PART OF THE BUILDING	LOCATION:	REAR PART OF THE BUILDING	LOCATION:	FRONT & LEFT SIDE OF THE BUILDING	LOCATION:	FRONT OF THE BUILDING
DIMENSION	1200mm x 1200mm	DIMENSION	1200mm x 1200mm	DIMENSION	1200mm x 600mm	DIMENSION	1200mm x 1200mm	DIMENSION	1800mm x 600mm	DIMENSION	3000mm x 4200mm
DESCRIPTION:	AWNING WINDOW: LOW-E TEMPERED GLASS 6 MM THK, REFLECTIVE FILM INSTALLED, SEALANT ON FRAME & GLASS EDGES; SAMPLE SHOULD BE PROVIDED BEFORE INSTALLATION.	DESCRIPTION:	AWNING WINDOW: LOW-E TEMPERED GLASS 6 MM THK, REFLECTIVE FILM INSTALLED, SEALANT ON FRAME & GLASS EDGES; SAMPLE SHOULD BE PROVIDED BEFORE INSTALLATION.	DESCRIPTION:	AWNING WINDOW: LOW-E TEMPERED GLASS 6 MM THK, REFLECTIVE FILM INSTALLED, SEALANT ON FRAME & GLASS EDGES; SAMPLE SHOULD BE PROVIDED BEFORE INSTALLATION.	DESCRIPTION:	MIXED AWNING & FIXED WINDOW: LOW-E TEMPERED GLASS 6 MM THK, REFLECTIVE FILM INSTALLED, SEALANT ON FRAME & GLASS EDGES; SAMPLE SHOULD BE PROVIDED BEFORE INSTALLATION.	DESCRIPTION:	MIXED AWNING & FIXED SEAMLESS WINDOW: LOW-E TEMPERED GLASS 6 MM THK, REFLECTIVE FILM INSTALLED, SEAMLESS GLASS EDGE TO EDGE INSTALLATION, SEALANT APPLICATION ON FRAME EDGES; SAMPLE SHOULD BE PROVIDED BEFORE INSTALLATION.	DESCRIPTION:	MIXED AWNING & FIXED WINDOW: LOW-E TEMPERED GLASS 6 MM THK, REFLECTIVE FILM INSTALLED, SEALANT ON FRAME & GLASS EDGES; SAMPLE SHOULD BE PROVIDED BEFORE INSTALLATION.
NO OF SET:	TWO (2) SET/S	NO OF SET:	TWO (2) SET/S	NO OF SET:	SIX (6) SET/S	NO OF SET:	FOUR (4) SET/S	NO OF SET:	TWO (2) SET/S	NO OF SET:	ONE (1) SET/S

TESDA INNOVATION CENTER - SOCCSKSARGEN
SCHEDULE OF WINDOWS
 SCALE 1:100 MTS

**FOR APPROVAL PLANS OF
REGIONAL TVET INNOVATION
CENTERS (RTICs) 2023**



MAIN OFFICE ADDRESS: TESDA COMPLEX, East Service Road SLEX, Taguig City

PROJECT TITLE:
**PROPOSED TESDA SOCCSKSARGEN
INNOVATION CENTER**

LOCATION: Spring, Abulid City, Saranggani Province

ARCHITECT:

AR/RUNIEL A. MENDOZA
HEAD, PMU-SIPTVETS
ENGINEERING SECTION

PROJECT MANAGER:

DIR. ENRICO C. BANARIO
PMU-SIPTVETS


PROJECT DIRECTOR:

SEC. SUHARTO T. MANGUDADATU, Ph.D.
PMU-SIPTVETS
SECRETARY, TESDA



SHEET CONTENTS:
SCHEDULE OF WINDOWS

SHEET NO.

A-13

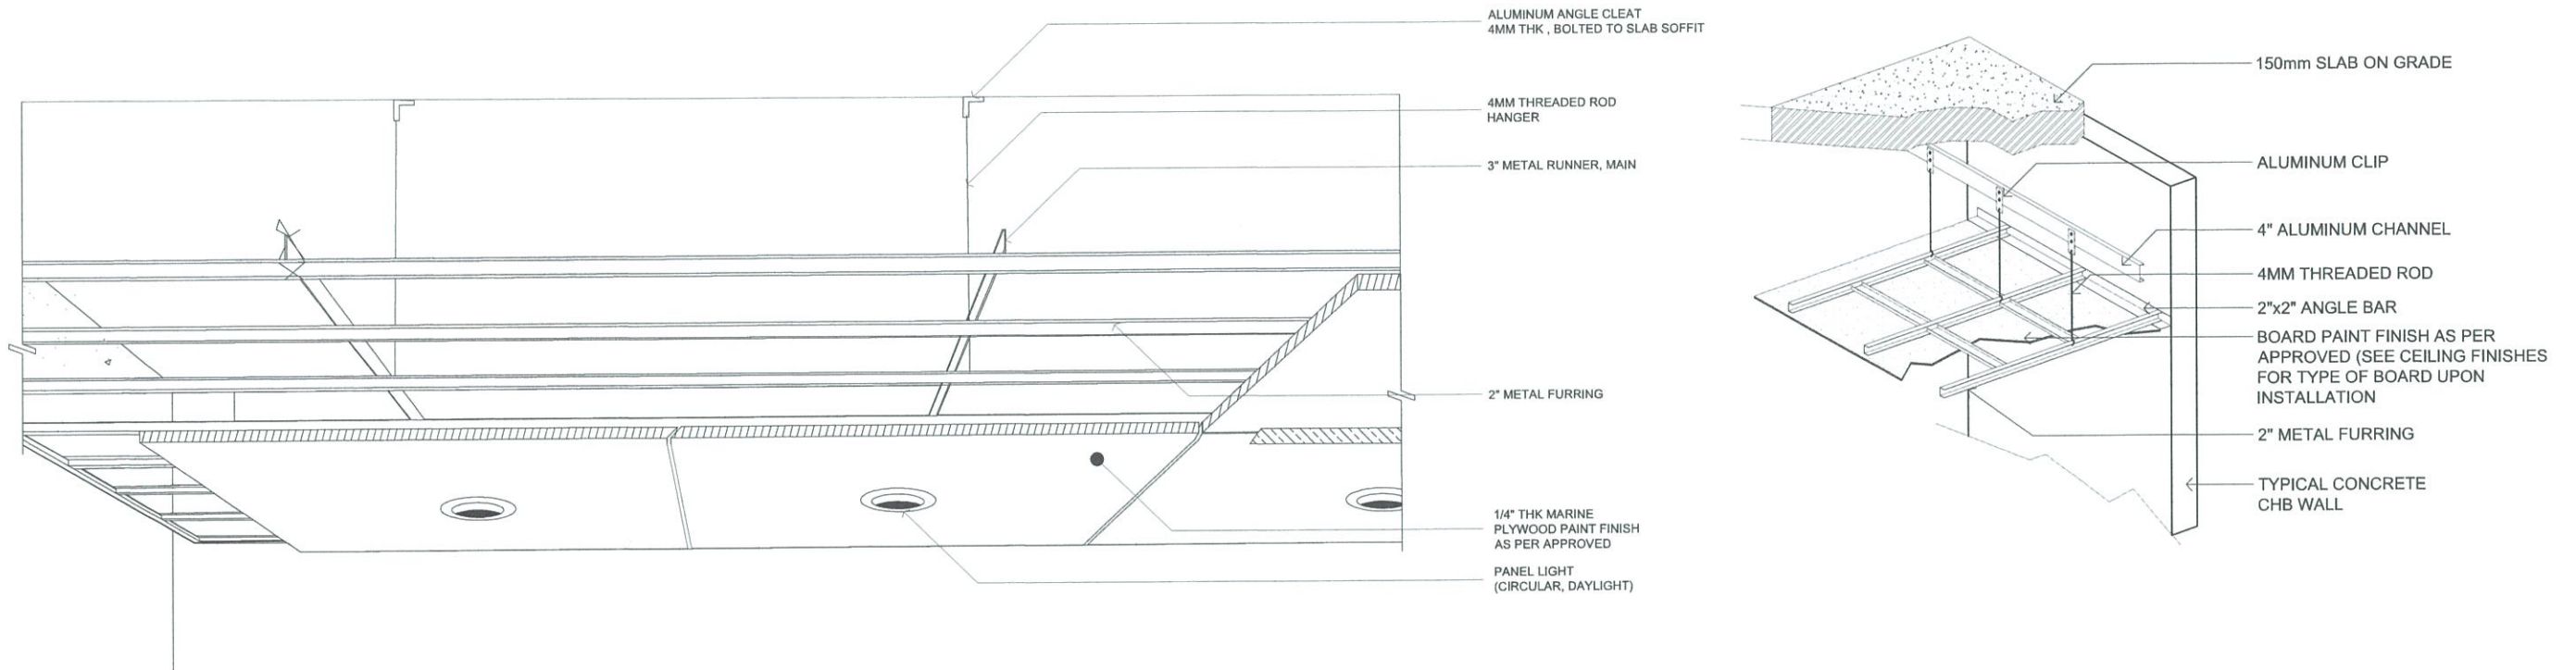

A
TESDA INNOVATION CENTER - SOCCSKSARGEN
ARCHITECTURAL DETAILS - 02
 SCALE NTS

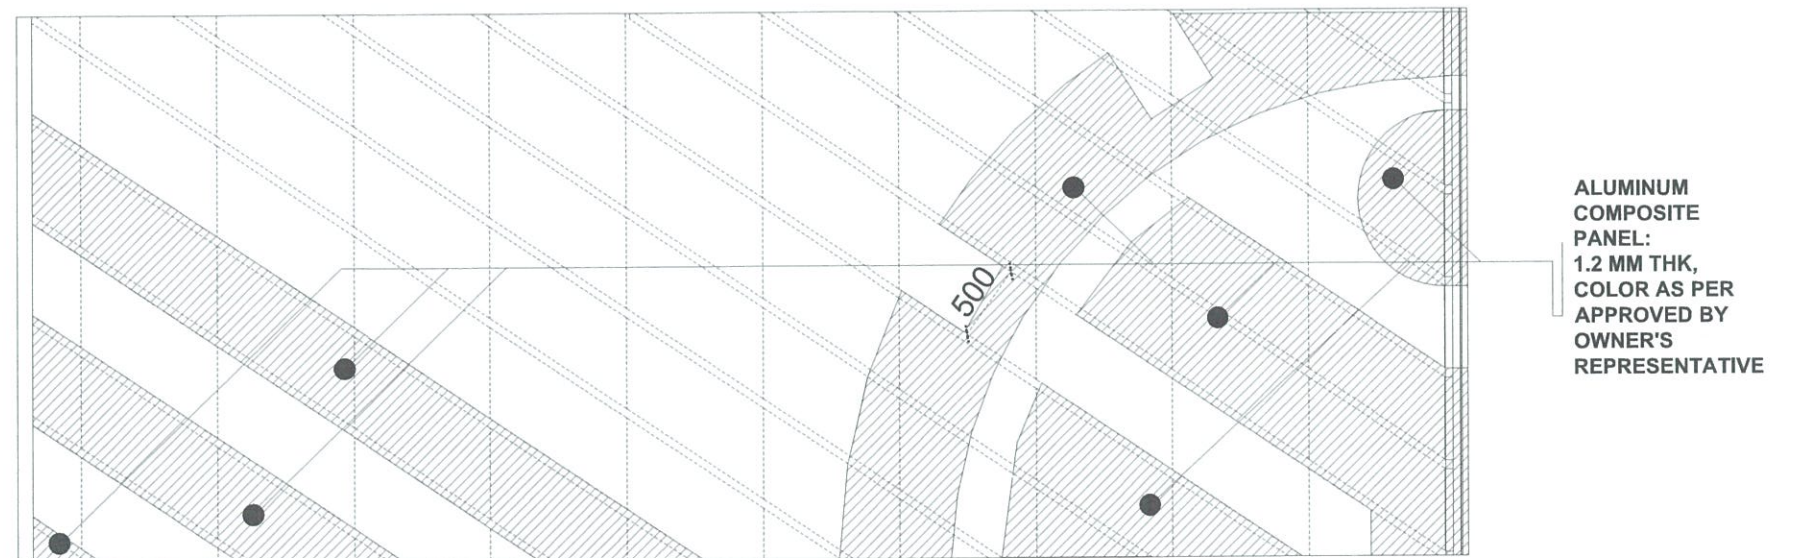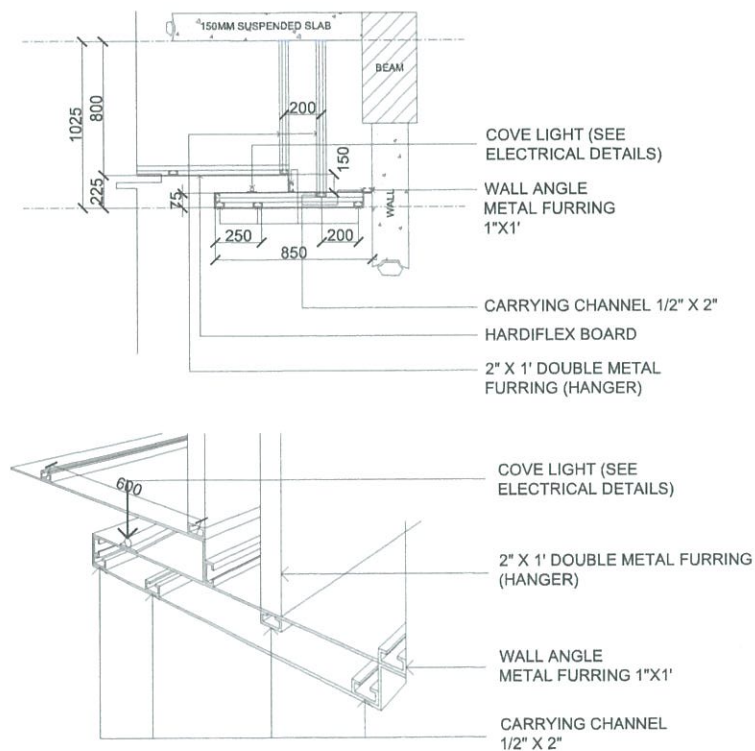

A
TESDA INNOVATION CENTER - RTC BATANGAS
ARCHITECTURAL DETAILS - 03
 SCALE 1:50 MTS

**FOR APPROVAL PLANS OF
REGIONAL TVET INNOVATION
CENTERS (RTICs) 2023**

PROJECT OWNER:
 **TECHNICAL EDUCATION
AND
SKILLS DEVELOPMENT
AUTHORITY**
MAIN OFFICE ADDRESS: TESDA COMPLEX, East Service Road SLEX, Taguig City

PROJECT TITLE:
**PROPOSED TESDA SOCCSKSARGEN
INNOVATION CENTER**
LOCATION: Spring, Alabid City, Sarangani Province

ARCHITECT:

AR. RUEL A. MENDOZA
HEAD, PMU-SIPTVETS
ENGINEERING SECTION

PROJECT MANAGER:

DIR. ENRIDO C. BANARIO
PMU-SIPTVETS

PROJECT DIRECTOR:

SEC. SUHARTO T. MANGUDADATU, Ph.D.
PMU-SIPTVETS
SECRETARY, TESDA

SHEET CONTENTS:
 ARCHITECTURAL DETAILS - 02

SHEET NO.
A-15